

N 55°12'53" E
35.91'

NINA RIDGE (PRIVATE STREET)
LOT 999 BLOCK 6

1/2" Iron Rod Set w/ cap
stamped "RICKMAN"

1/2" Iron Rod Set w/ cap
stamped "RICKMAN"

LOT 4, BLK 27, CB 4695

1/2" Iron Rod Set w/ cap
stamped "RICKMAN"

10' Electric, gas,
telephone, & cable
TV Esmnt (Plat)

20' Building
Setback (Plat)

1 SITE PLAN
1/16"=1'-0"

IMPERVIOUS COVERAGE	
AREA COVERED	7,370 S.F.
TOTAL LOT AREA	26,111 S.F.
TOTAL IMPERVIOUS COVERAGE	28%

TAG #	Botanic Name	Trunk Diameter	Canopy Diameter
7160	OAK	22"	60
7162	OAK	8"	48
7163	OAK	8"	50
7164	OAK	21"	70
7165	OAK	20"	58
7166	OAK	22"	66
7167	OAK	19"	64
7168	OAK	12"	30
7169	OAK	17"	26
7170	OAK	8"	20
7171	OAK	12"	32
7172	OAK	11"	30
7173	OAK	15"	36
7174	OAK	16"	34
7175	OAK	16"	40
7176	OAK	13"	40
7177	OAK	14"	32

CURVE	RADIUS	ARC LENGTH	CHORD LENGTH	CHORD BEARING	DELTA ANGLE
C1	775.00'	99.63'	99.56'	N 51°31'55" E	7°21'56"

This drawing is an instrument of service and shall remain the property of Silas Lacey, L.L.C. No part of this drawing may be reproduced, stored in a retrieval system, or transmitted in any form or by any means, electronic, mechanical, photocopying, recording, or by any information storage and retrieval system, without the prior written approval of Silas Lacey, L.L.C. Silas Lacey, L.L.C. warrants that the design, preparation, and distribution of this drawing is for the sole purpose of the project and is not to be used for any other purpose in connection with the project or for the benefit of any other party. Any abridgment or violation of the rights of Silas Lacey, L.L.C. will be prosecuted to the fullest extent of the law.

SILAS LACEY
DESIGN & CONSTRUCTION ADMINISTRATION

SILAS LACEY
DESIGNS

PHONE: (830) 237-2166
EMAIL: info@silaslacey.com
WEBSITE: silaslaceydesigns.com



INVENTORY HOME FOR
LIFESTYLE BY STADLER
11106 NINA RIDGE
THE CANYONS AT SCENIC LOOP
SAN ANTONIO, TEXAS

DATE:	1-28-22
DRAWN BY:	JZ
CHECKED BY:	JZ
REVIEWED BY:	

LIFESTYLE
BY STADLER

830.215.8776
StadlerCustomHomes.com

SHEET NO:
A2
SITE PLAN
2 OF 8 SHEETS

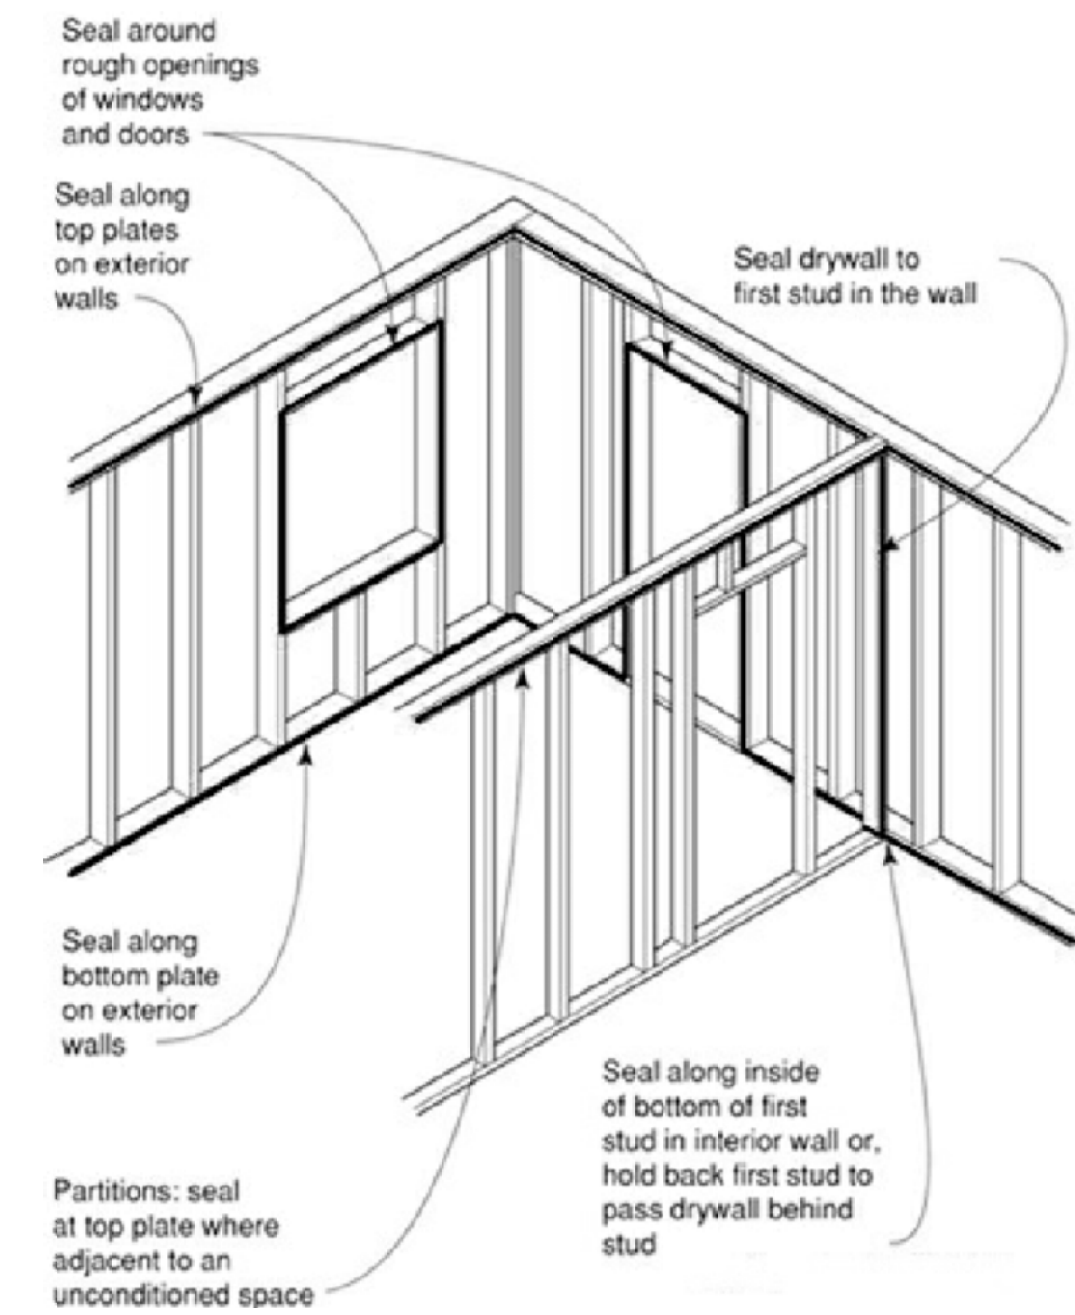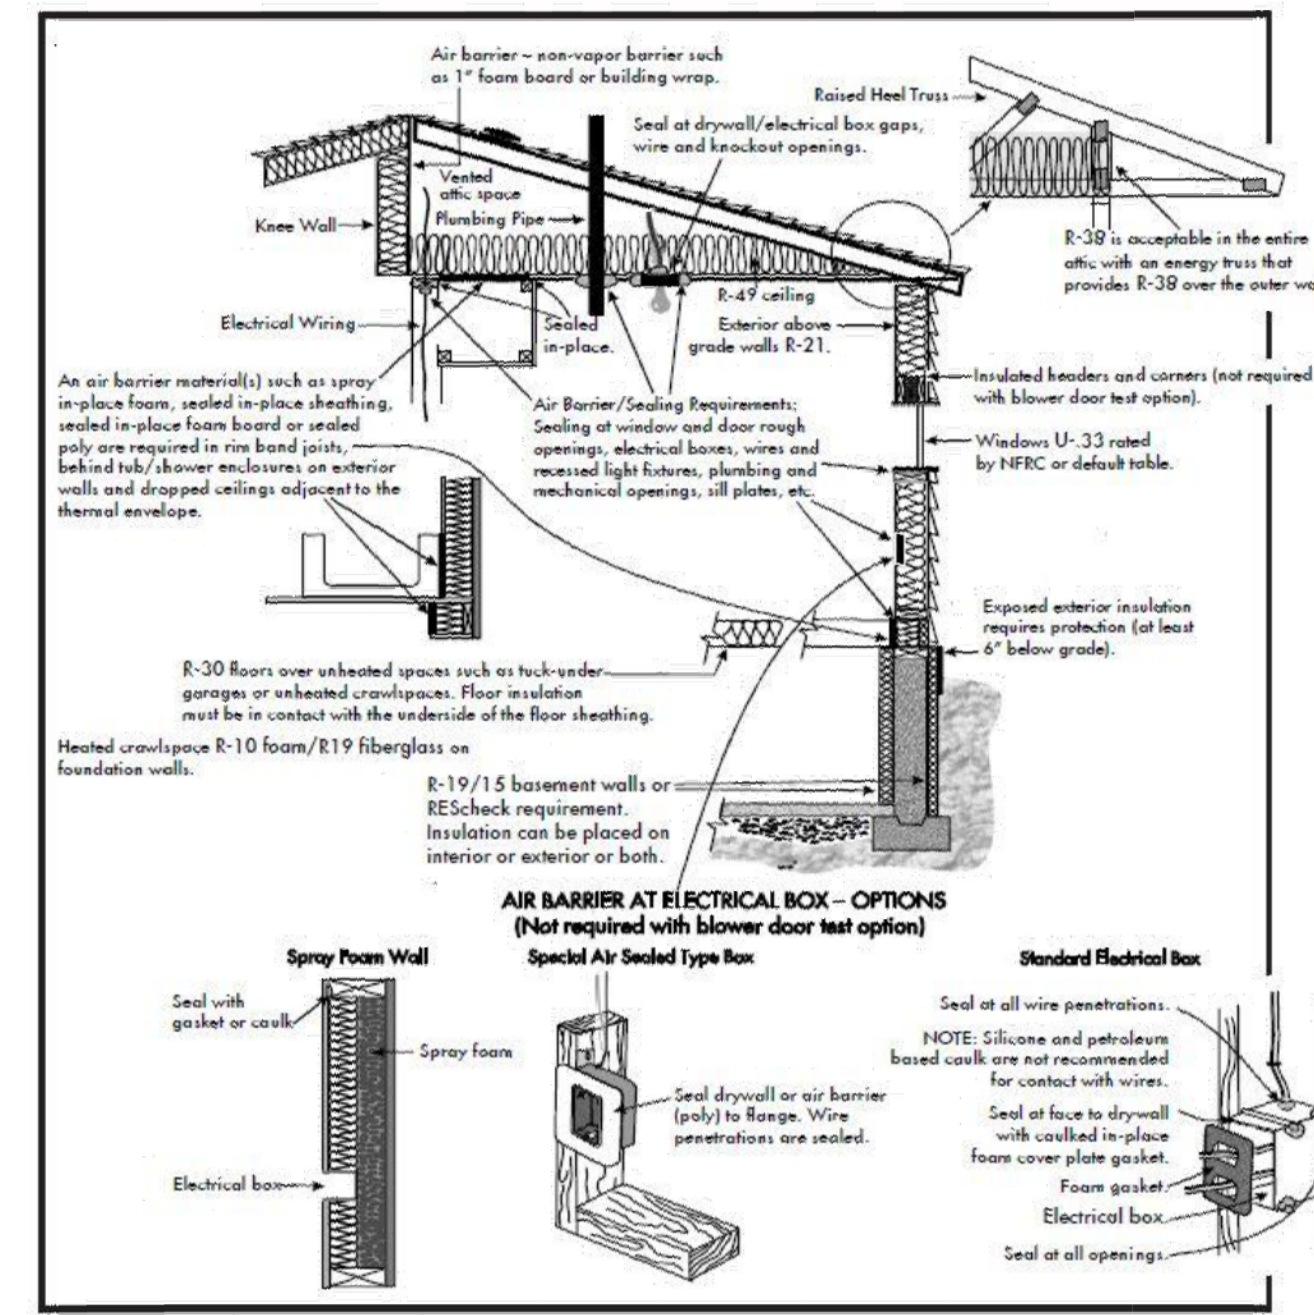

This drawing is an instrument of service and shall remain the property of Silas Lacey, L.L.C. It is to be used only for the project and site described in the contract documents. It is not to be used for any other project, site, or purpose without the written approval of Silas Lacey, L.L.C. Silas Lacey, L.L.C. is not responsible for the design or construction of any other person's work or for any other person's work in connection with this project. Any abridgment or violation of the rights of Silas Lacey, L.L.C. shall be prosecuted to the fullest extent of the law.

SILAS LACEY
DESIGN & CONSTRUCTION ADMINISTRATION

SILAS LACEY
DESIGNS

PHONE: (830) 237-2166
EMAIL: info@silaslacey.com
WEBSITE: silaslaceydesigns.com


INVENTORY HOME FOR
LIFESTYLE BY STADLER
11106 NINA RIDGE
THE CANYONS AT SCENIC LOOP
SAN ANTONIO, TEXAS

DATE:	1-28-22
DRAWN BY:	JZ
CHECKED BY:	JZ
REVIEWED BY:	

LIFESTYLE
BY STADLER

830.215.8776
StadlerCustomHomes.com

SHEET NO:
A5
EXTERIOR ELEVATIONS
5 OF 8 SHEETS

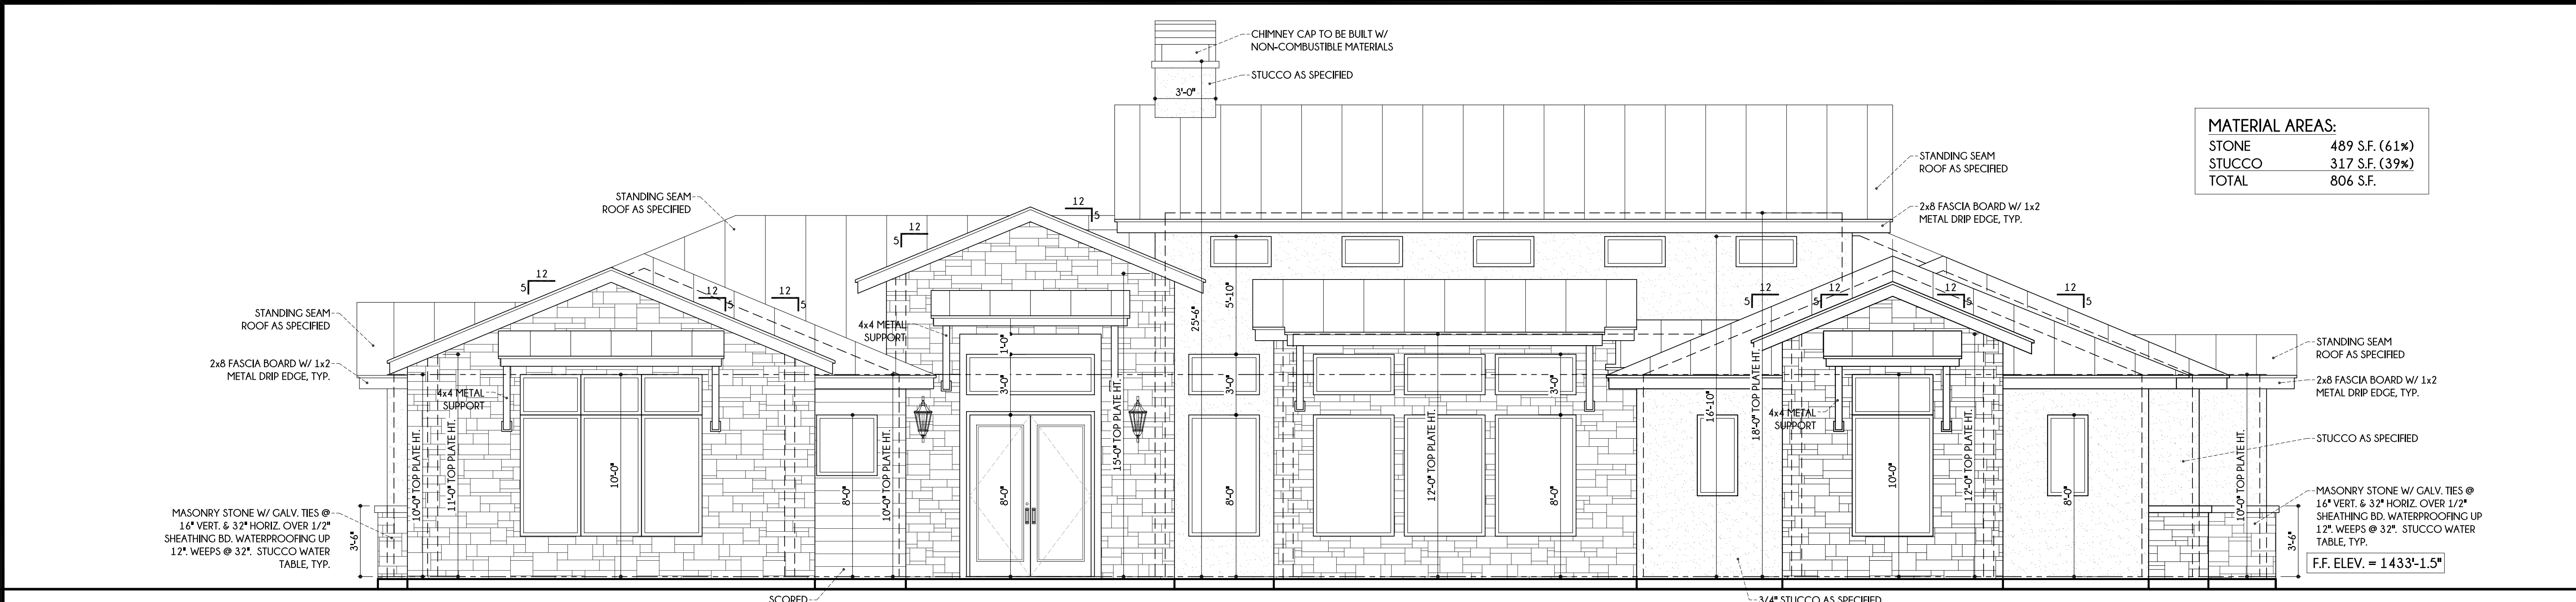


MATERIAL AREAS:

STONE	489 S.F. (61%)
STUCCO	317 S.F. (39%)
TOTAL	806 S.F.

NOTE: 18" MAX EXPOSED FOUNDATION PER SUBDIVISION REQUIREMENTS

1 FRONT ELEVATION 1/4"=1'-0"

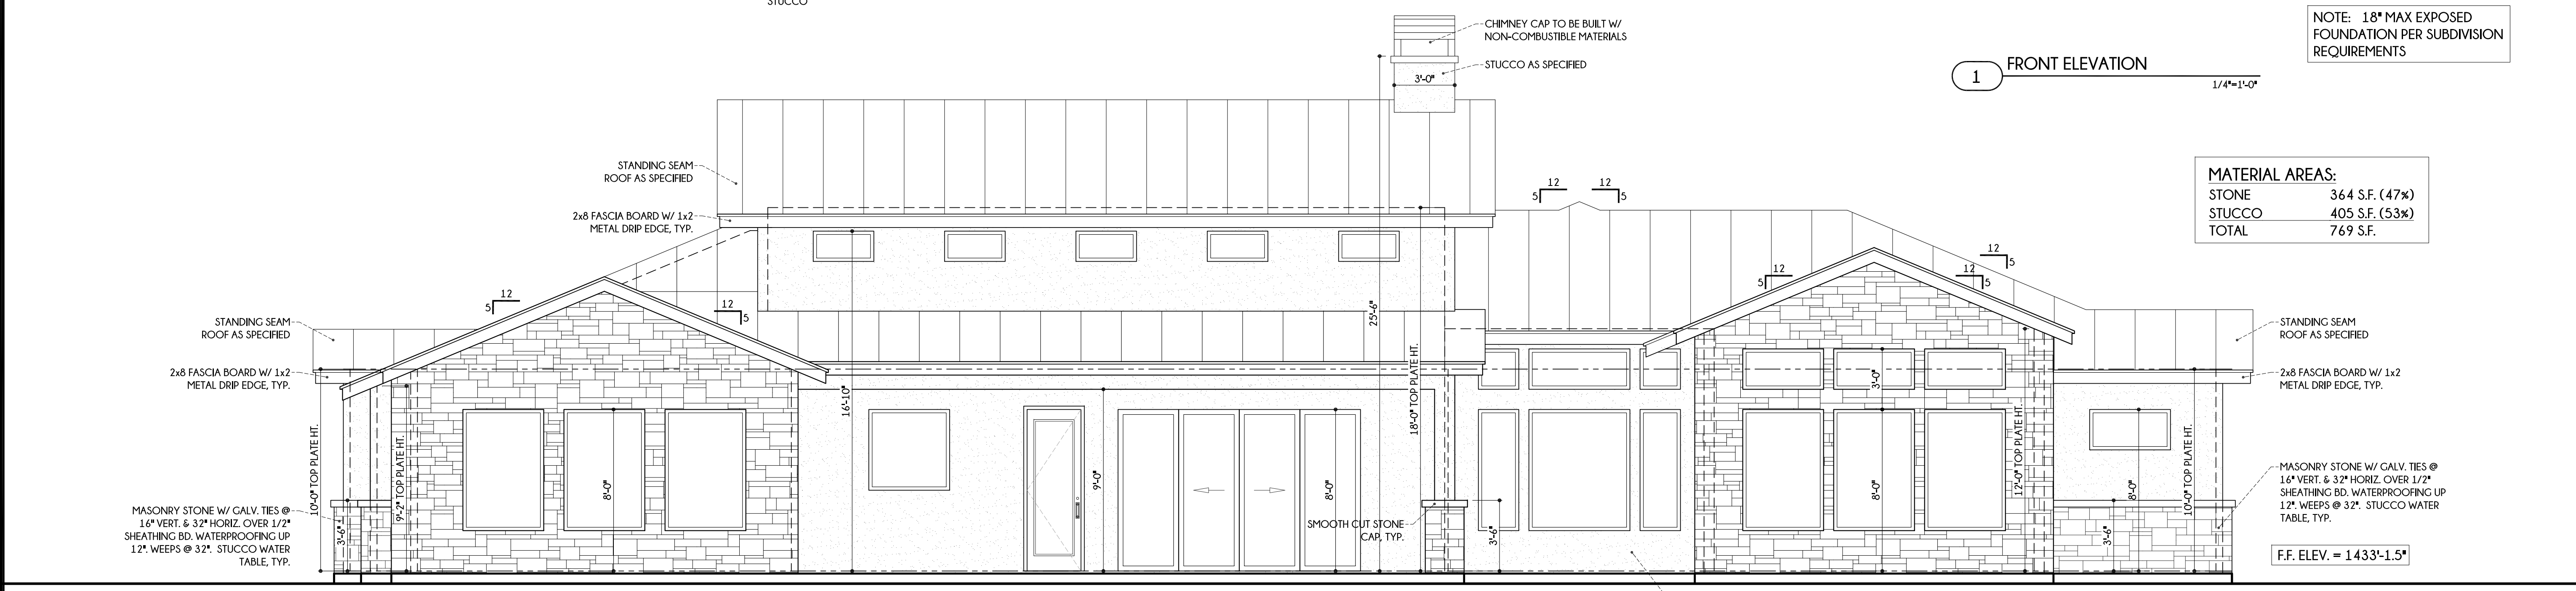


MATERIAL AREAS:

STONE	364 S.F. (47%)
STUCCO	405 S.F. (53%)
TOTAL	769 S.F.

F.F. ELEV. = 1433'-1.5"

2 REAR ELEVATION 1/4"=1'-0"

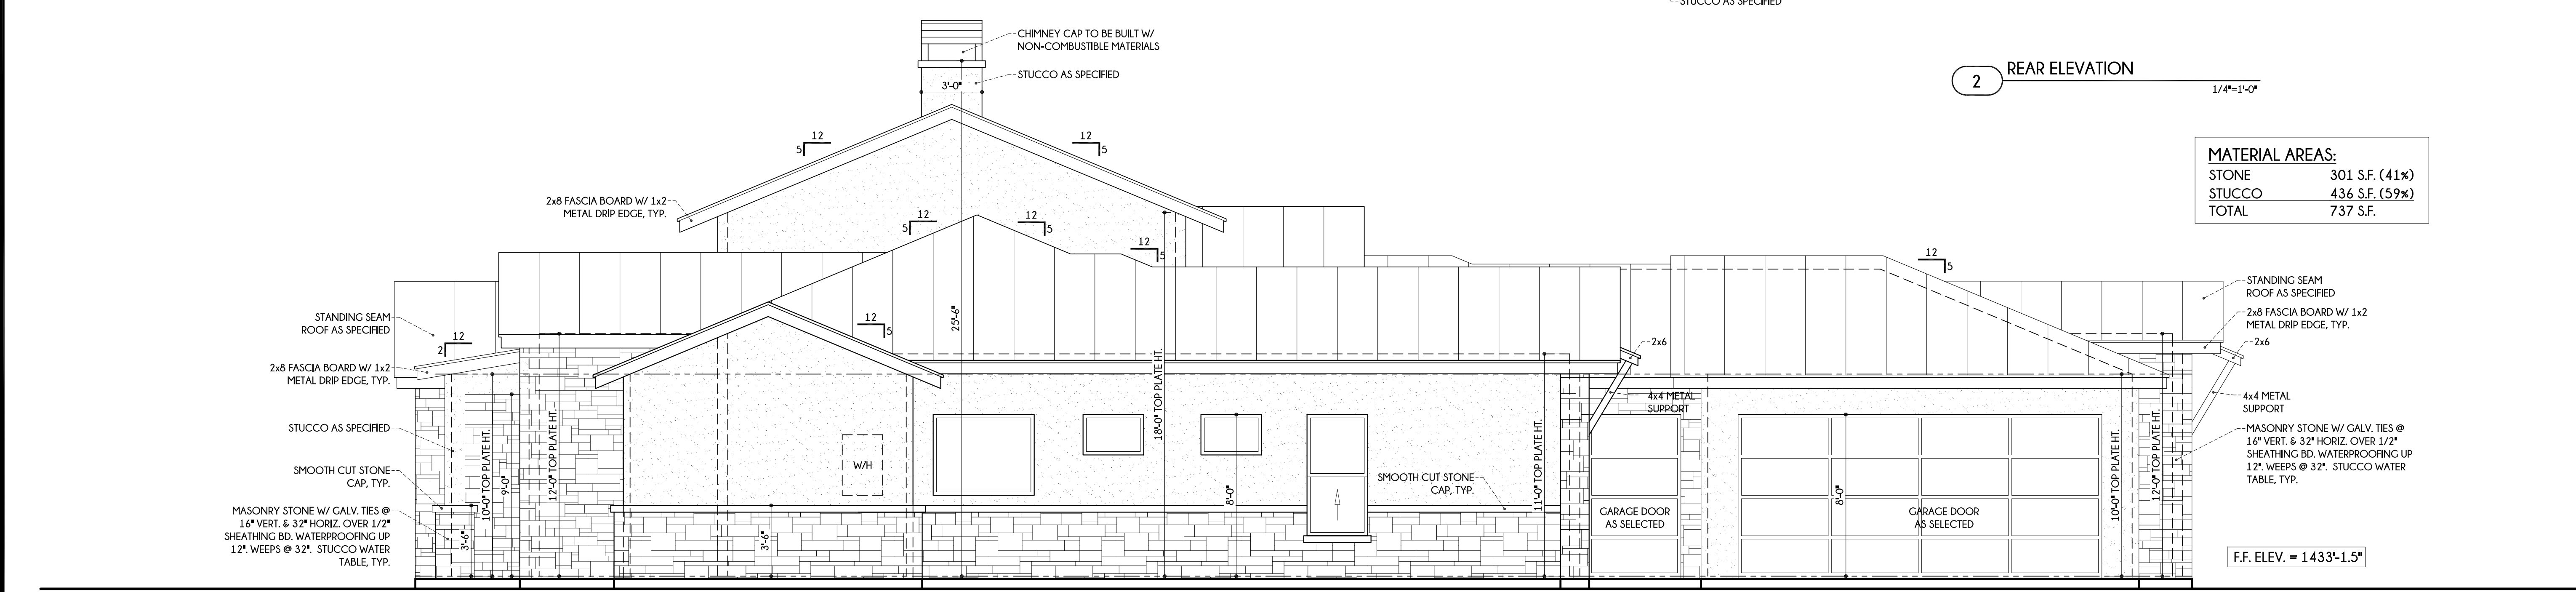

MATERIAL AREAS:

STONE	301 S.F. (41%)
STUCCO	436 S.F. (59%)
TOTAL	737 S.F.

F.F. ELEV. = 1433'-1.5"

3 LEFT ELEVATION 1/4"=1'-0"

This drawing is an instrument of service and shall remain the property of Silas Lacey, L.L.C. It is to be used only for the project and site described herein. It is not to be reproduced, copied, or disseminated in any form without the written approval of Silas Lacey, L.L.C. Any abridgment or violation of the rights of Silas Lacey, L.L.C. shall be prosecuted to the fullest extent of the law.

SILAS LACEY
DESIGN & CONSTRUCTION ADMINISTRATION

SILAS LACEY
DESIGNS

PHONE: (830) 237-2166
EMAIL: info@silaslacey.com
WEBSITE: silaslaceydesigns.com

INVENTORY HOME FOR
LIFESTYLE BY STADLER
11106 NINA RIDGE
THE CANYONS AT SCENIC LOOP
SAN ANTONIO, TEXAS

DATE:	1-28-22
DRAWN BY:	JZ
CHECKED BY:	JZ
REVISION:	


LIFESTYLE
BY STADLER

830.215.8776
StadlerCustomHomes.com


SHEET NO:
A6
EXTERIOR ELEVATIONS
6 OF 8 SHEETS

MATERIAL AREAS:

STONE	335 S.F. (29%)
STUCCO	515 S.F. (71%)
TOTAL	850 S.F.

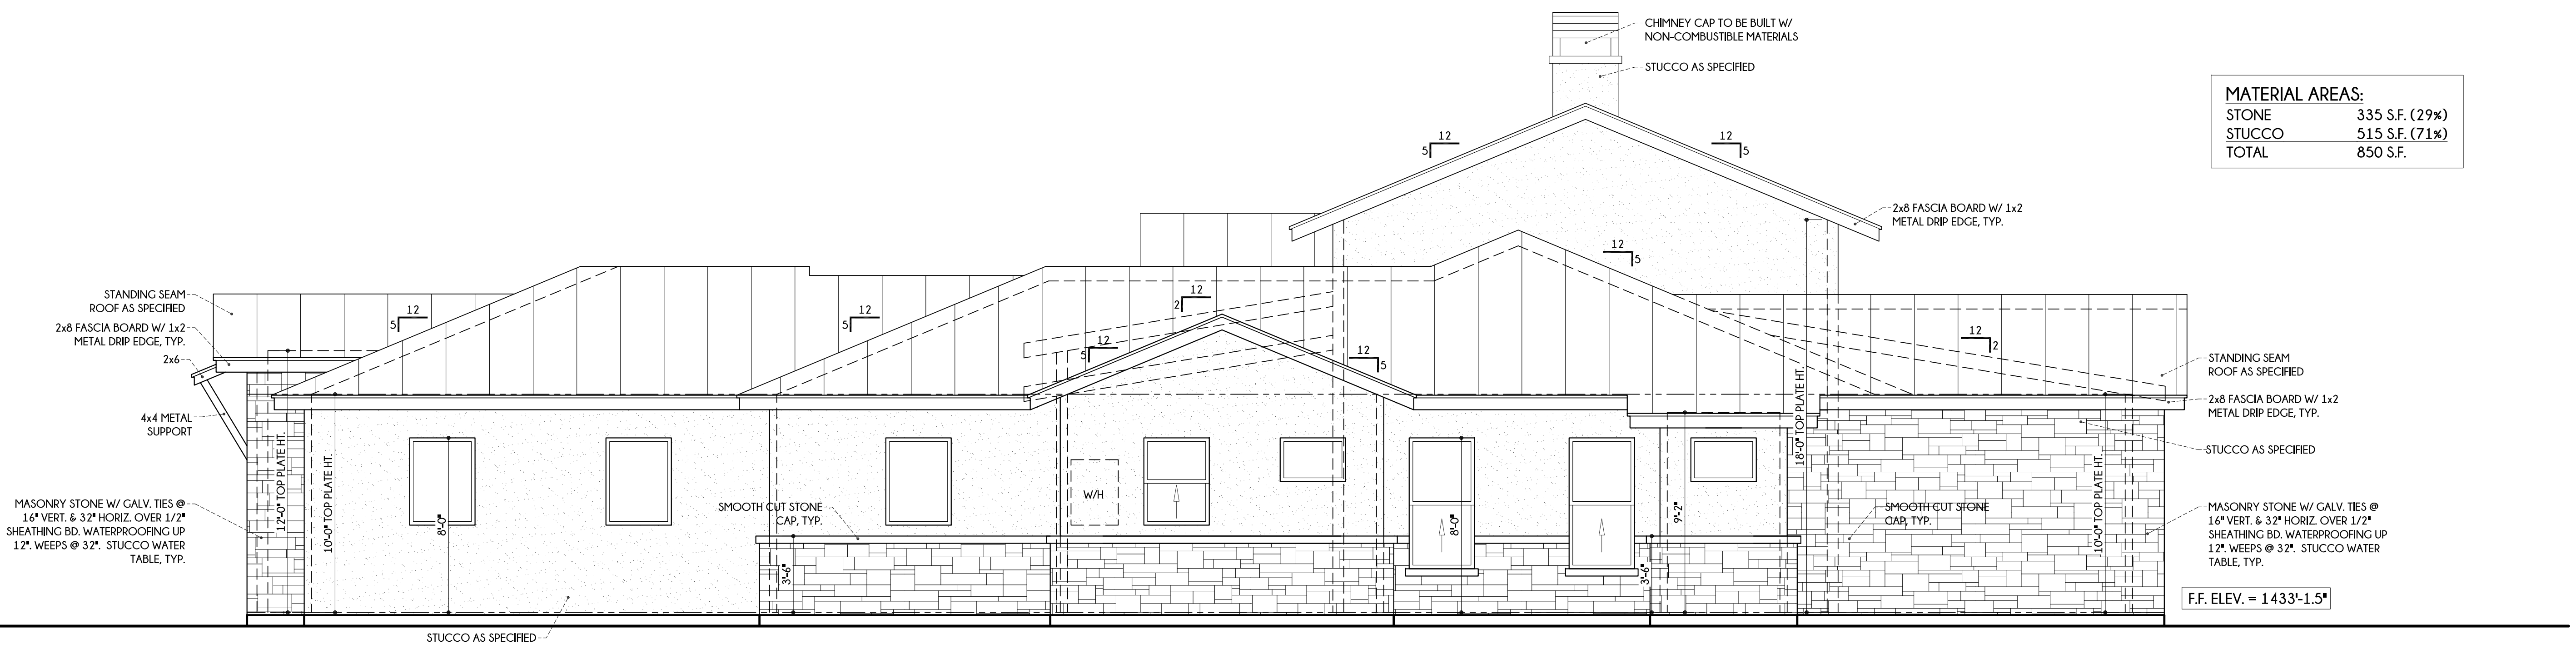


1 RIGHT ELEVATION 1/4"=1'-0"

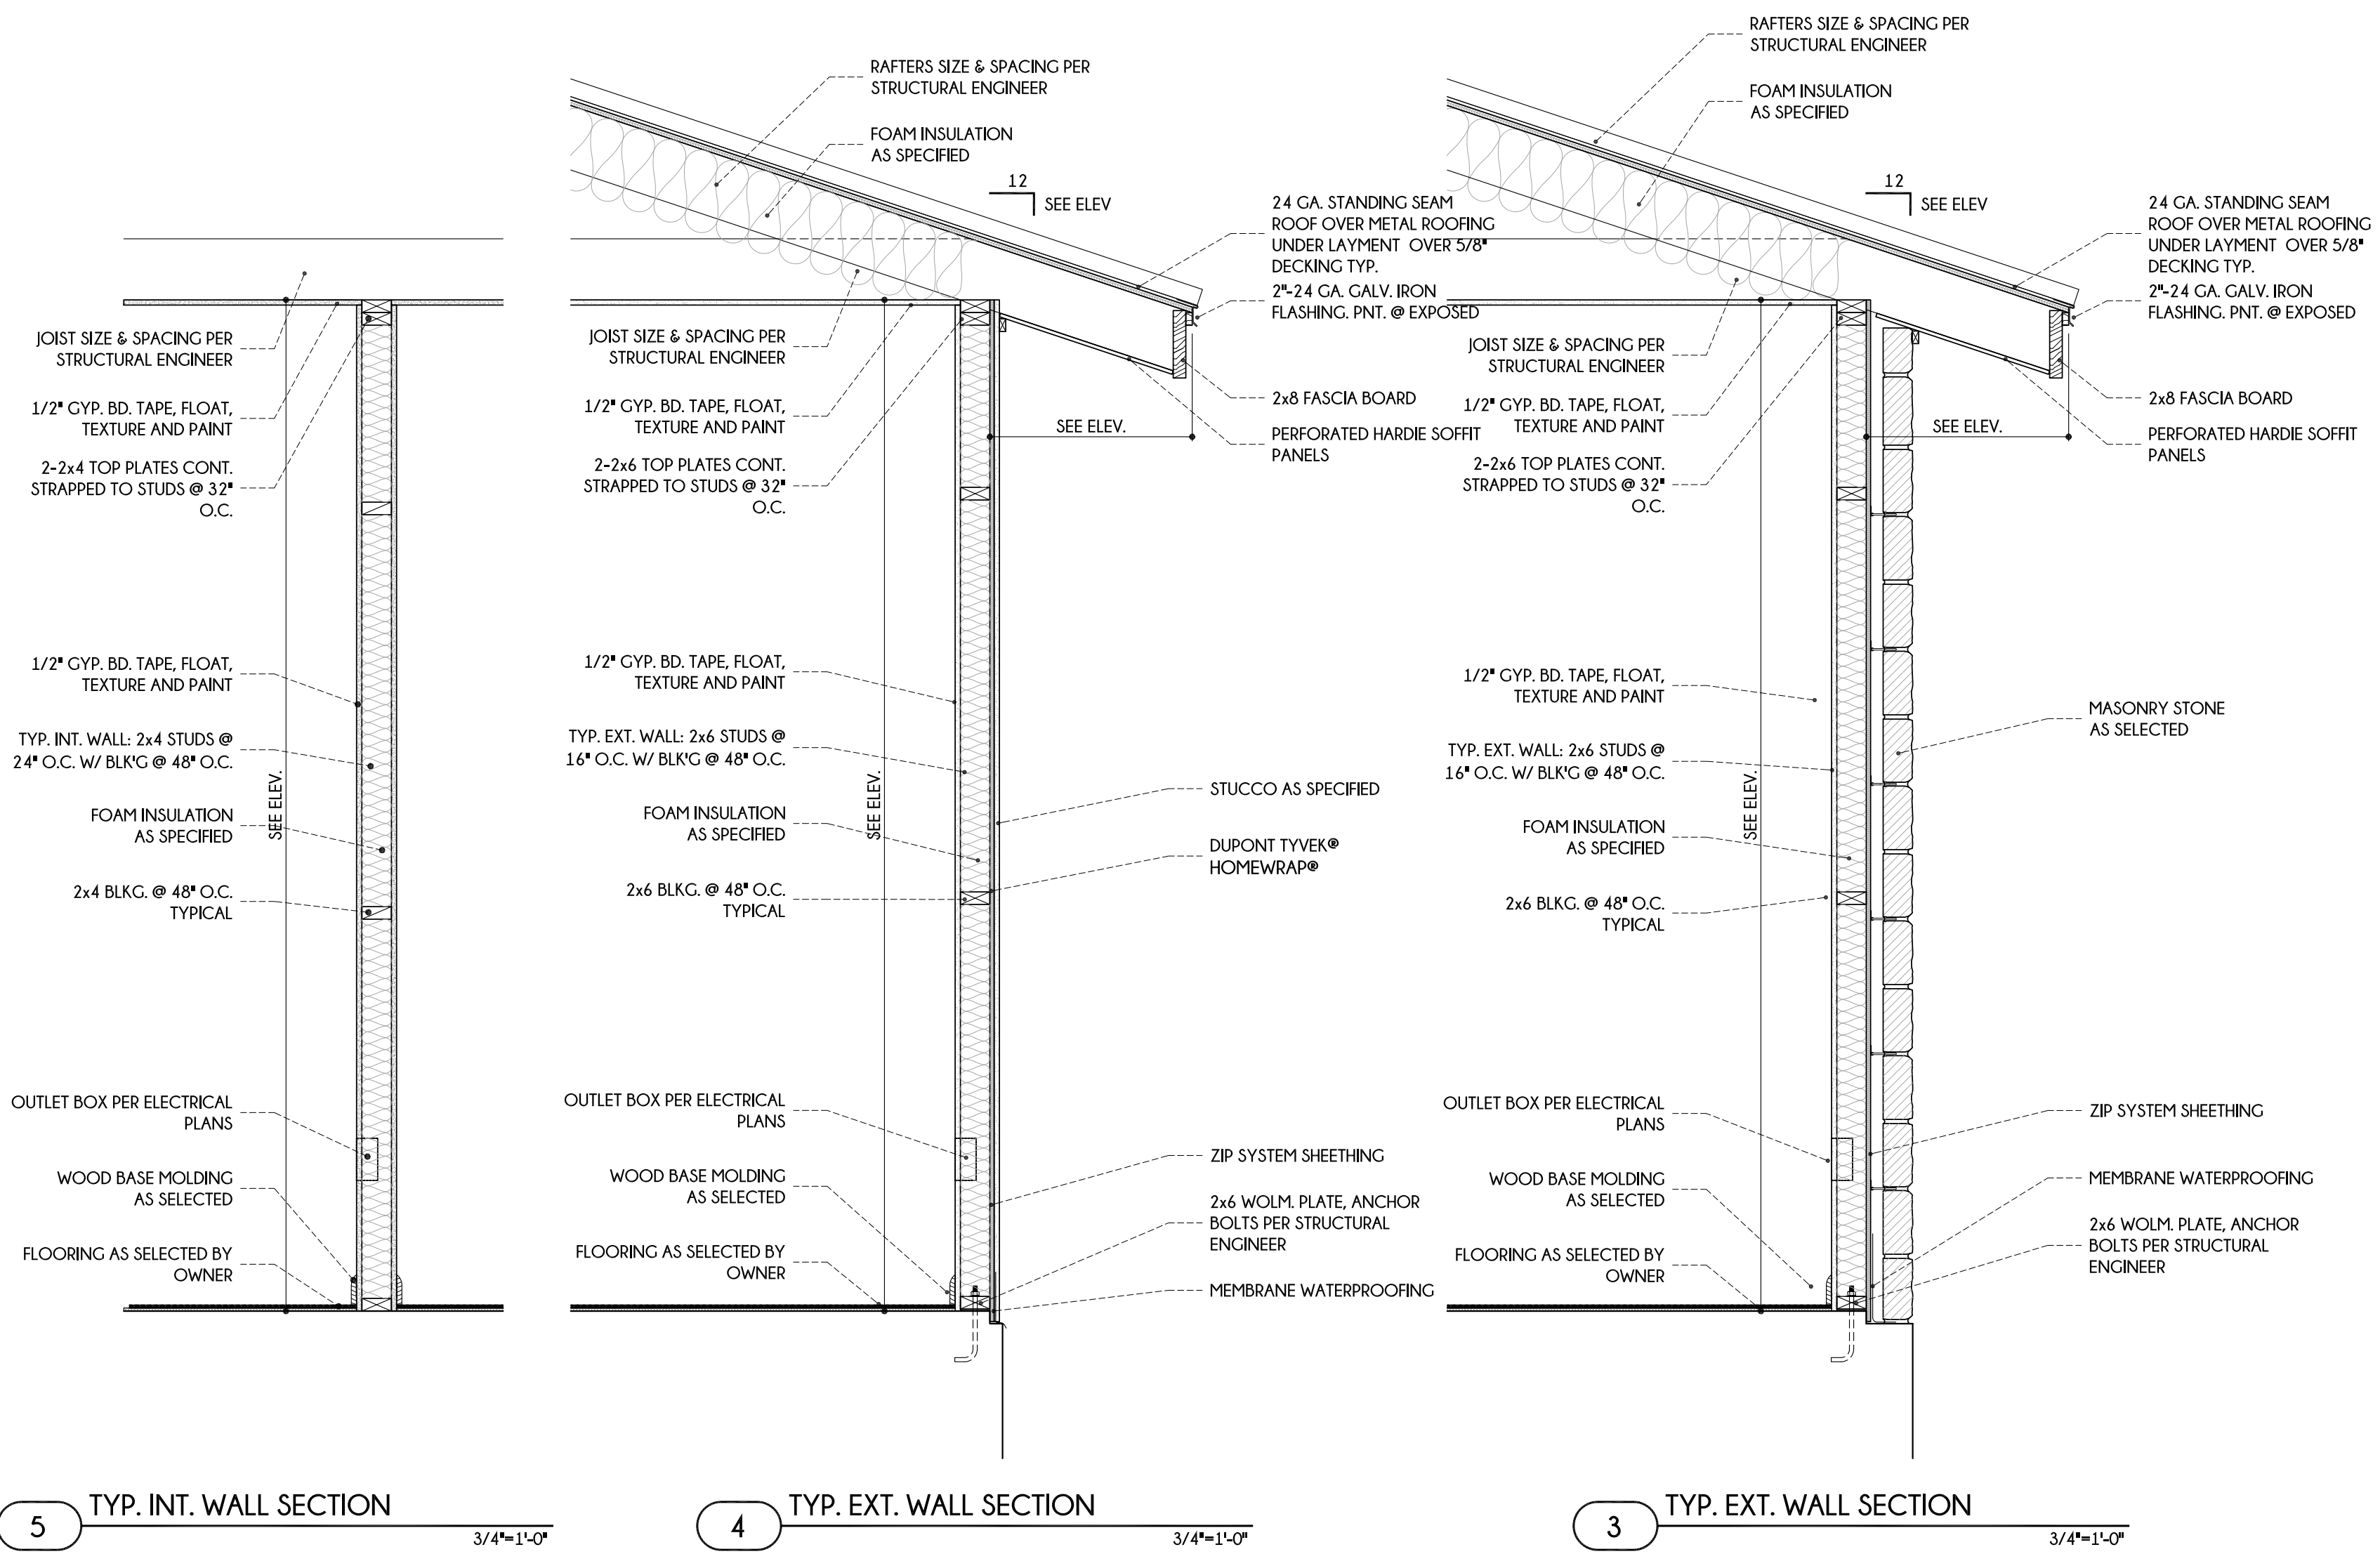

5 TYP. INT. WALL SECTION 3/4"=1'-0"






   
 


 
 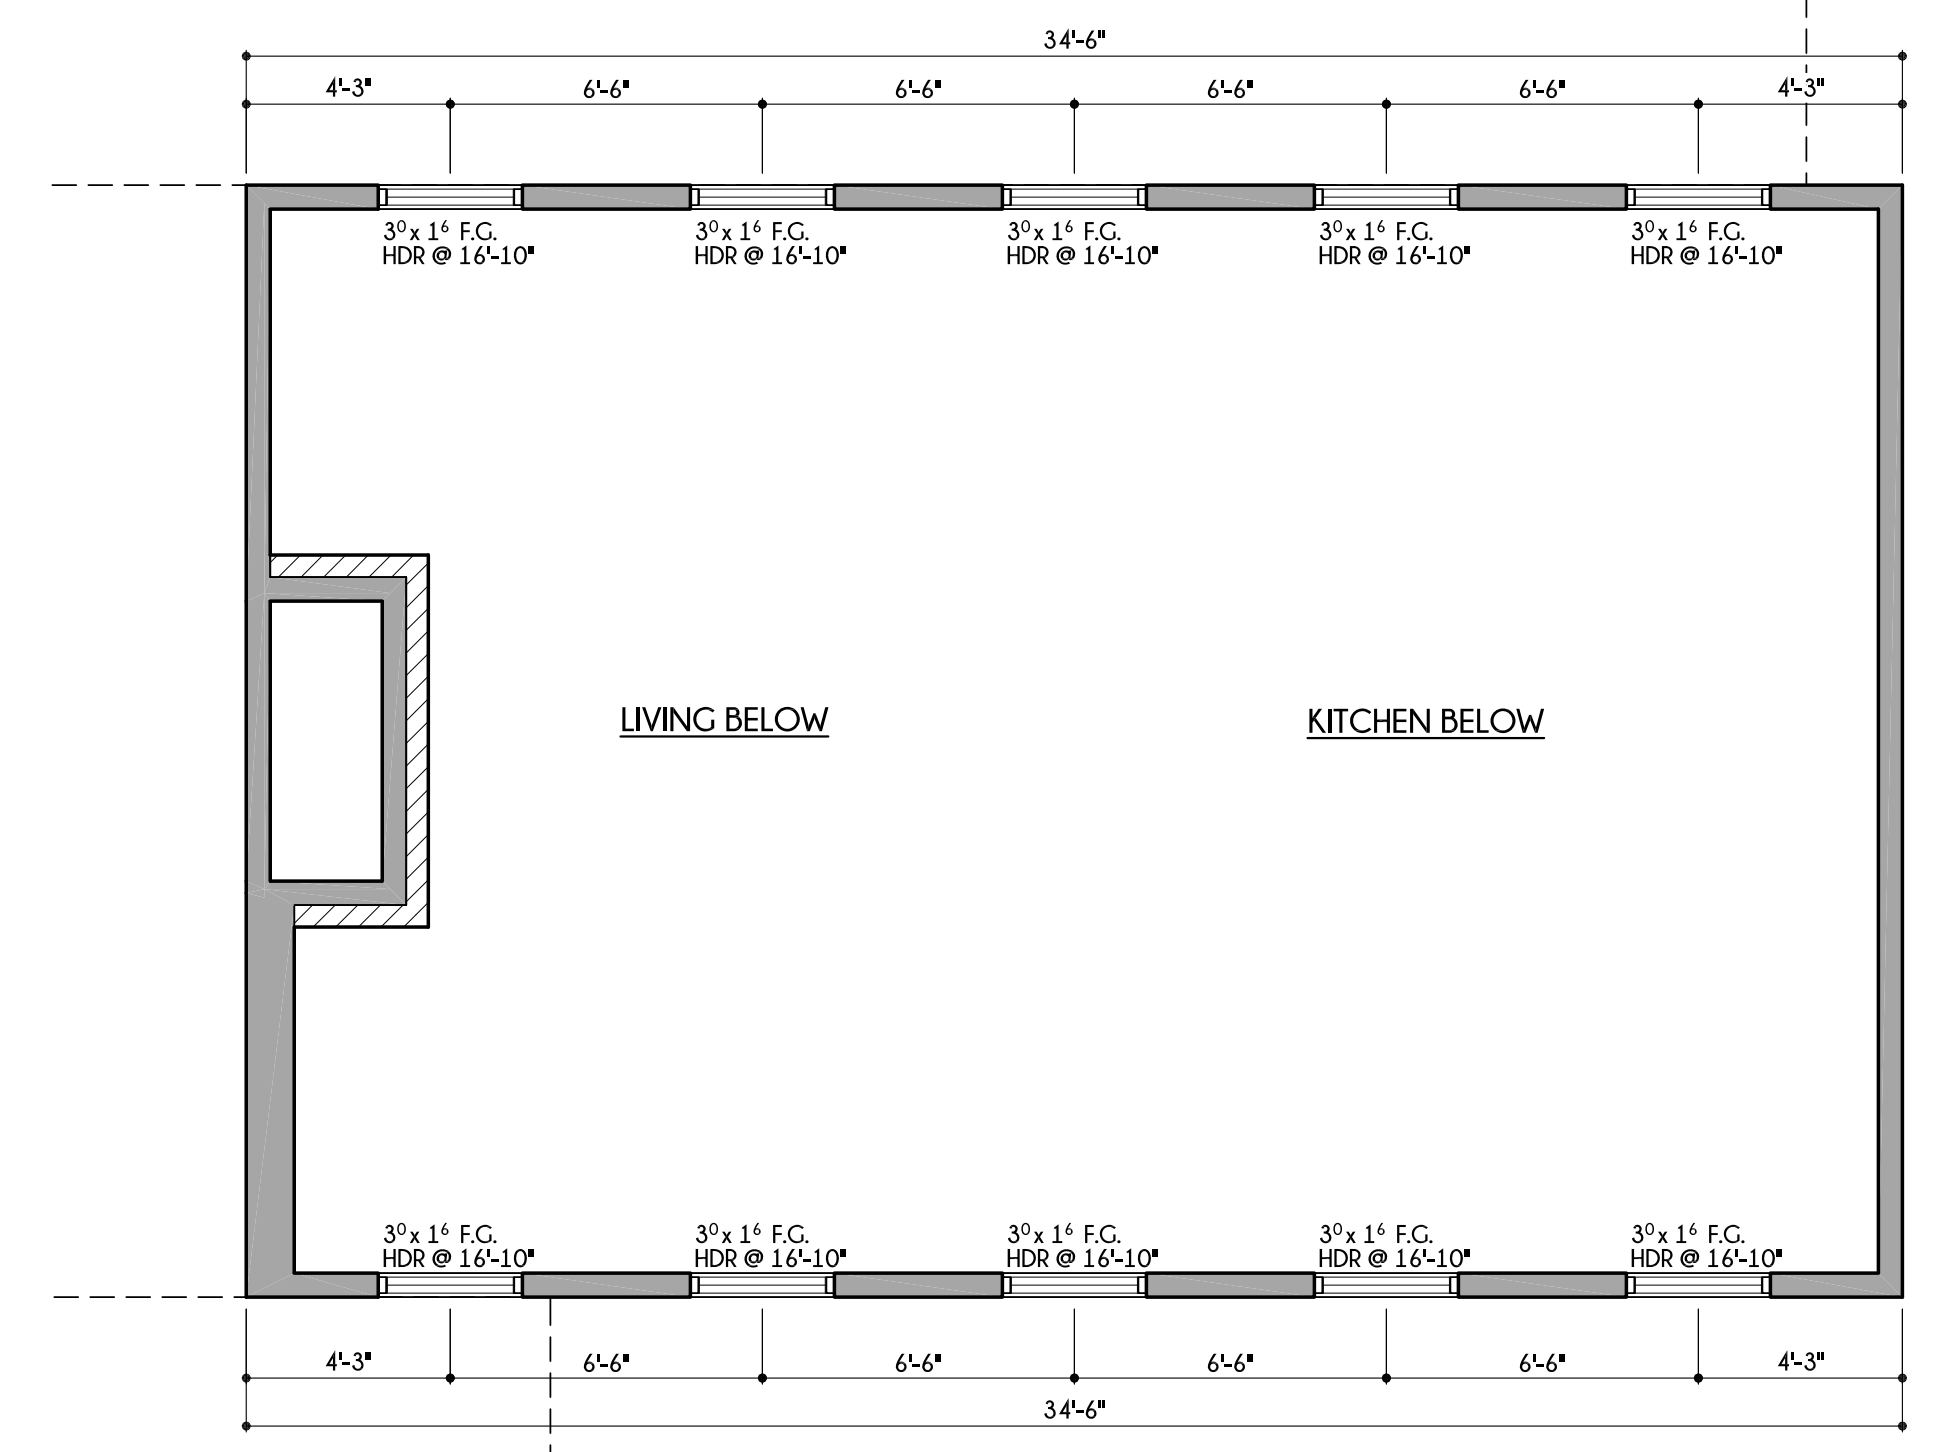

 
 

 

 
 

 
4 TYP. EXT. WALL SECTION 3/4"=1'-0"


3 TYP. EXT. WALL SECTION 3/4"=1'-0"



2 CLERESTORY PLAN 1/4"=1'-0"

LEGEND

-  CEILING FAN AS SELECTED BY OWNER
-  DIRECTIONAL RECESSED LIGHT FIXTURES
-  RECESSED LIGHTING
-  PENDANT LIGHTING AS SELECTED BY OWNER
-  VAPOR PROOF LIGHT FIXTURE
-  WALL MOUNTED/SCONCE LIGHT FIXTURE
-  CEILING MOUNTED LIGHT FIXTURE
-  VENT/LAMP FIXTURE
-  HEAT/VENT/LAMP FIXTURE
-  FLOOR PLUG LOCATED BY OWNER
-  DUPLEX OUTLET
-  QUAD OUTLET
-  GROUND FAULT DUPLEX OUTLET
-  WATER PROOF DUPLEX OUTLET
-  220V OUTLET
-  TELEPHONE / DATA
-  CABLE OUTLET
-  LED LIGHT FIXTURE
-  SMOKE ALARM
-  GARAGE OPENER PUSH BUTTON
-  SPEAKER

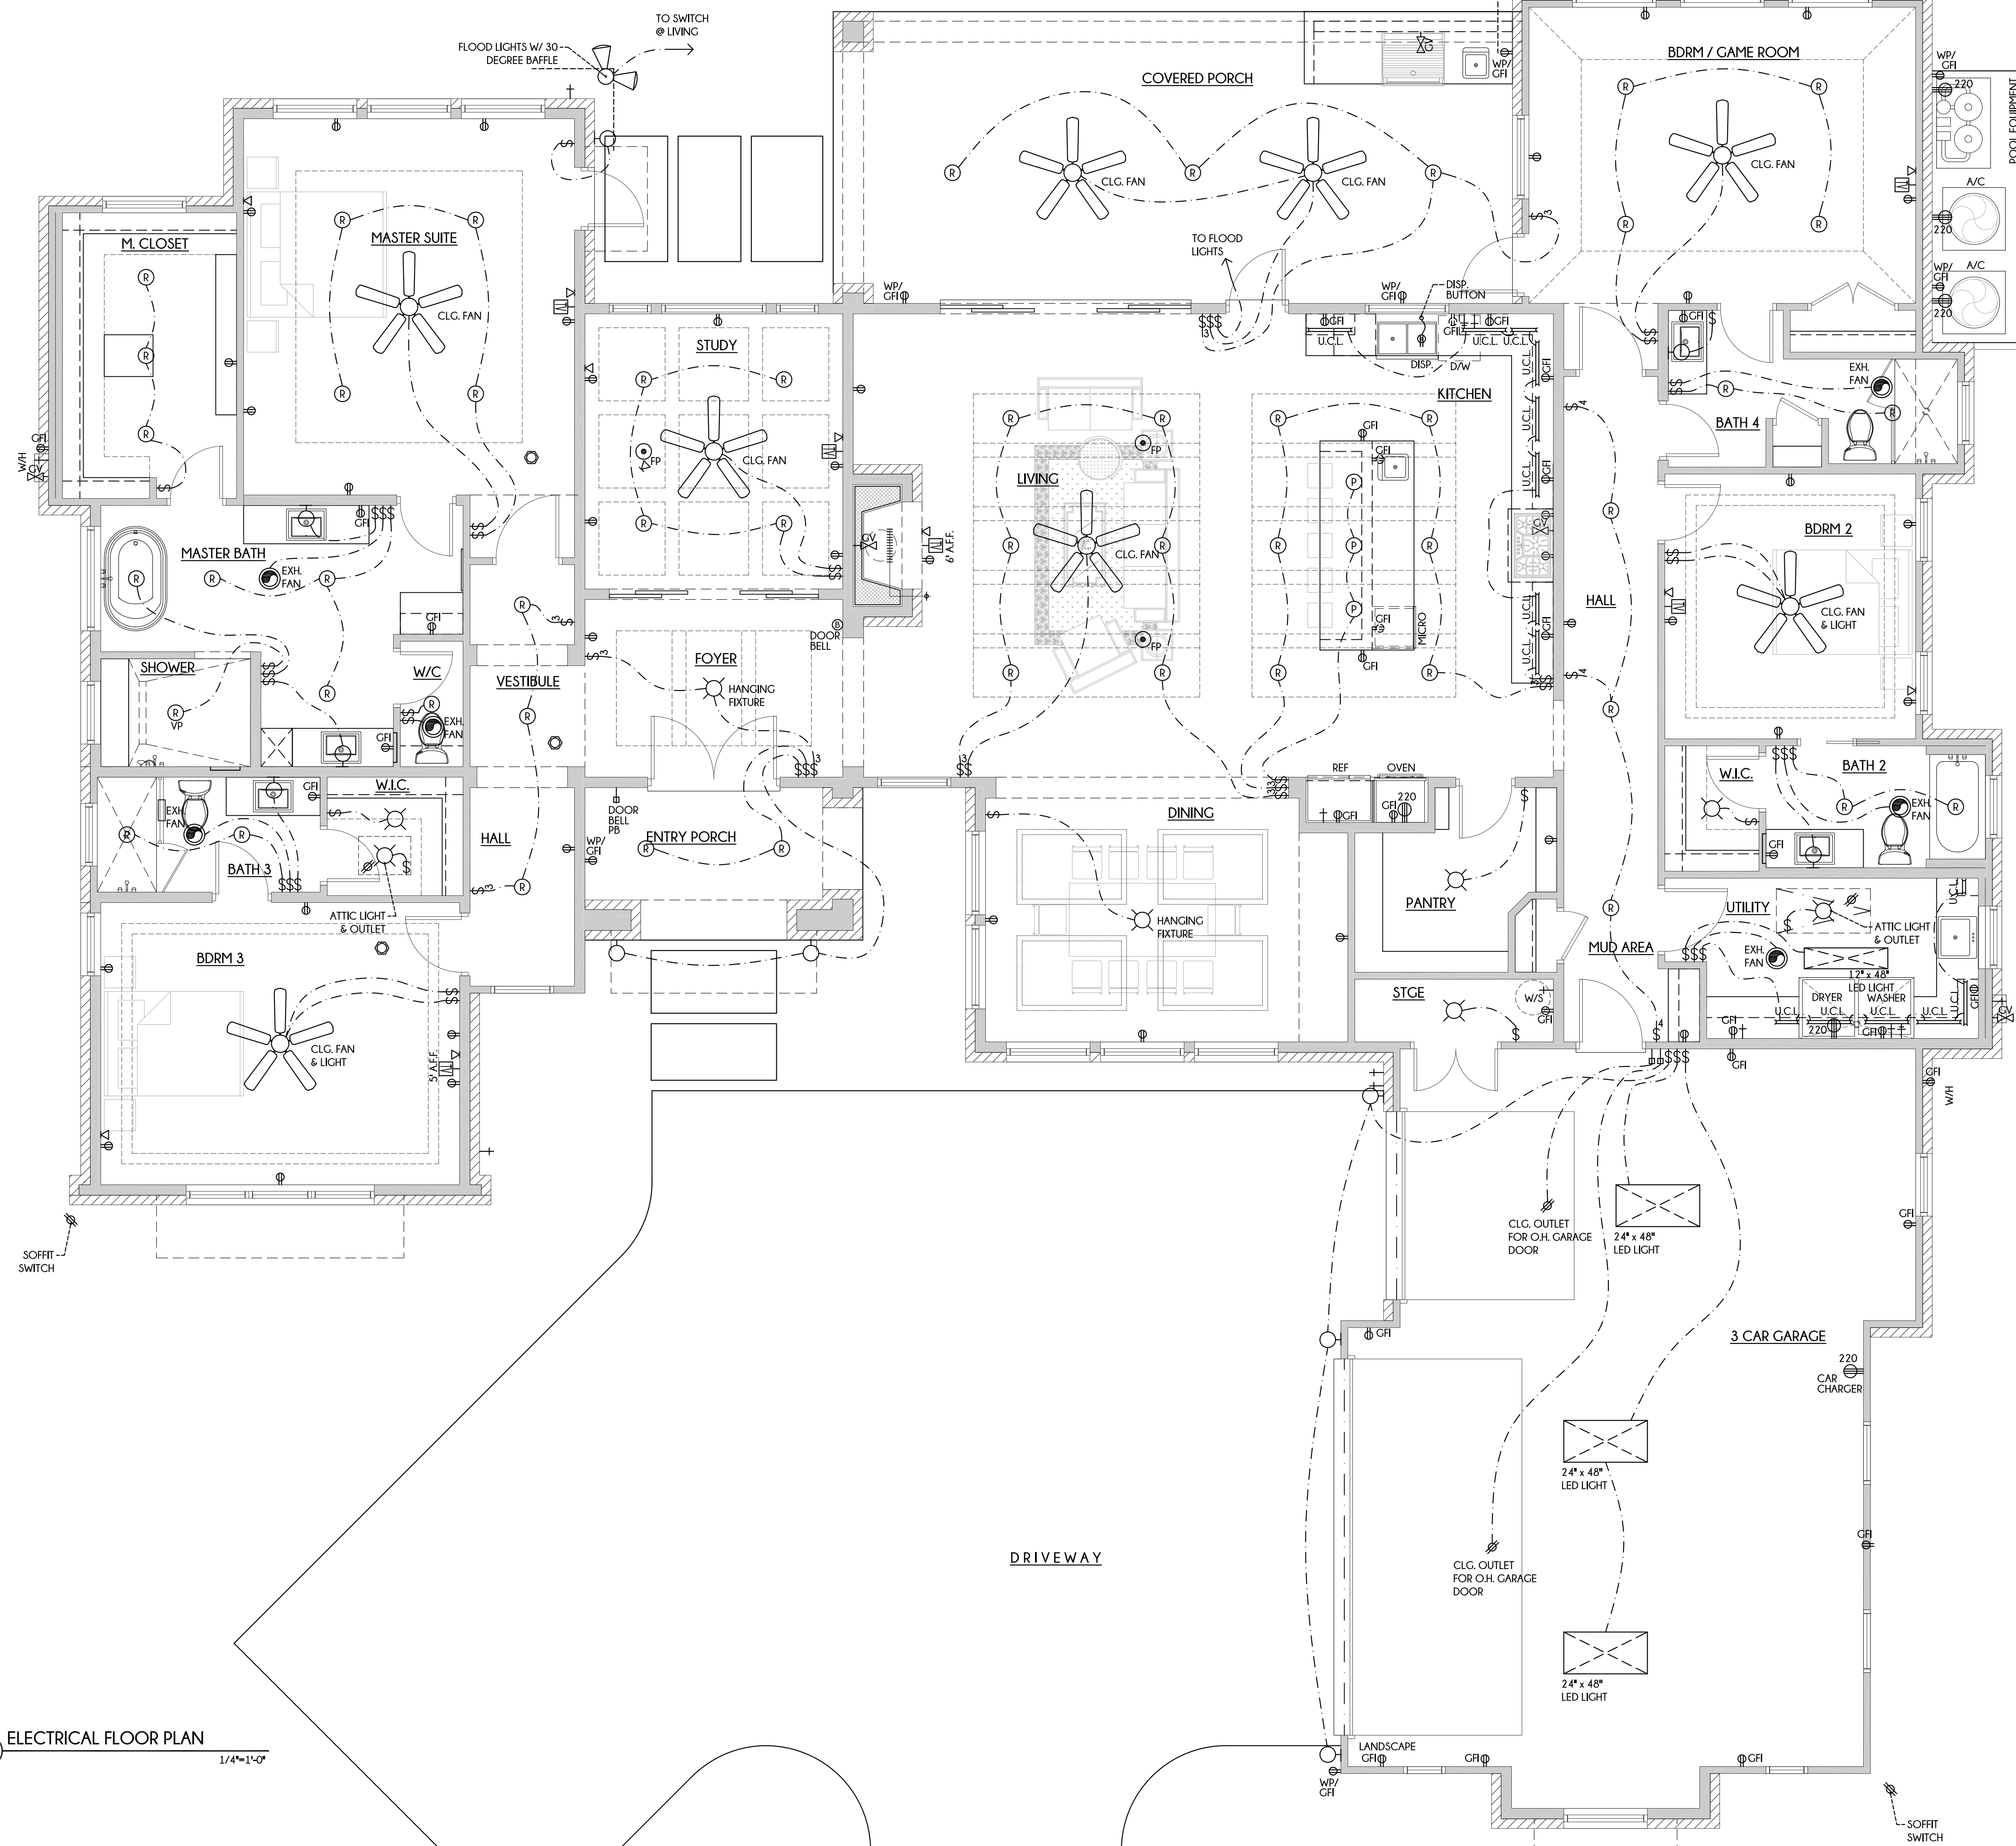

1 ELECTRICAL FLOOR PLAN
1/4"=1'-0"

This drawing is an instrument of service and shall remain the property of Silas Lacey, L.L.C. Any reproduction or use of this drawing without the written approval of Silas Lacey, L.L.C. is prohibited. The drawings are prepared in accordance with the applicable codes and standards. The drawings are not to be used for any other purpose without the written approval of Silas Lacey, L.L.C. Any abridgment or violation of the rights of Silas Lacey, L.L.C. shall be prosecuted to the fullest extent possible.

SILAS LACEY
DESIGN & CONSTRUCTION ADMINISTRATION

SILAS LACEY
DESIGNS

PHONE: (830) 237-2166
EMAIL: info@silaslacey.com
WEBSITE: silaslacedesigns.com


INVENTORY HOME FOR
LIFESTYLE BY STADLER
11106 NINA RIDGE
THE CANYONS AT SCENIC LOOP
SAN ANTONIO, TEXAS

DATE:	1-28-22
DRAWN BY:	JZ
CHECKED BY:	JZ
REVIEWED BY:	


LIFESTYLE
BY STADLER

830.215.8776
StadlerCustomHomes.com


SHEET NO:
A7
ELECTRICAL FLOOR PLAN
7 OF 8 SHEETS

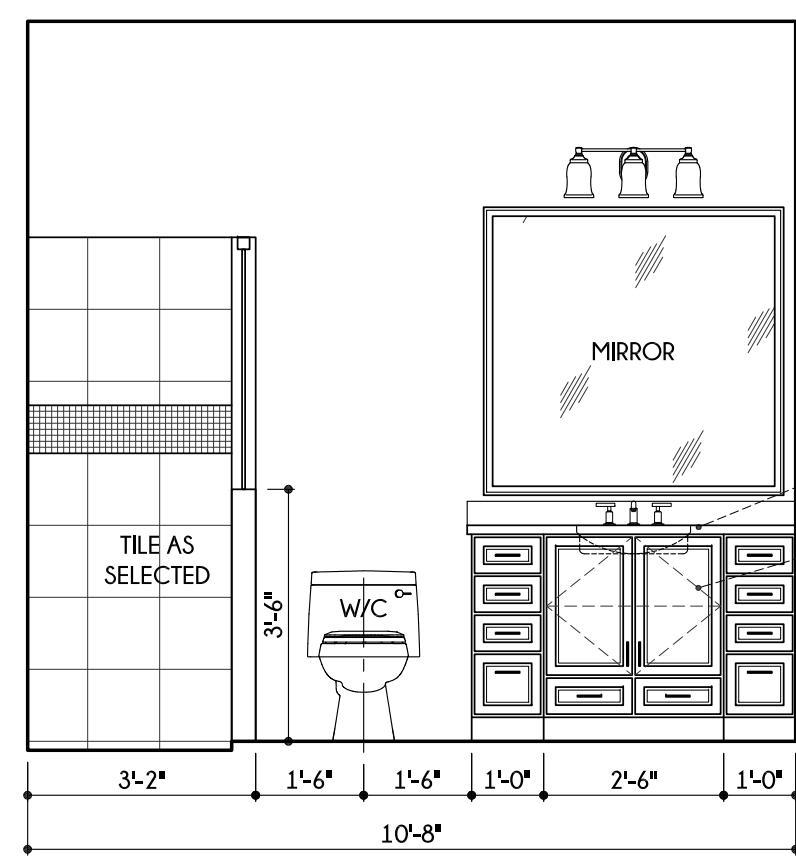


1 BATH 3
3/8"=1'-0"

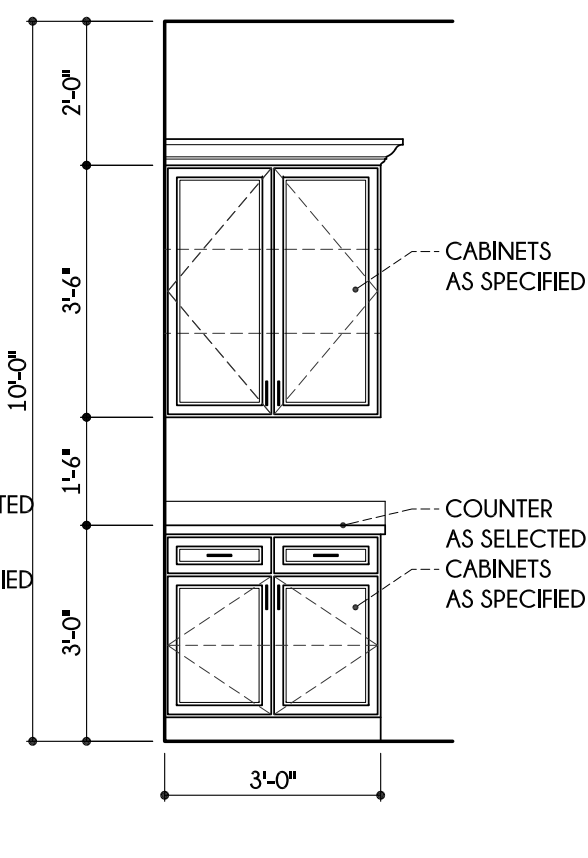


2 MASTER BATH
3/8"=1'-0"

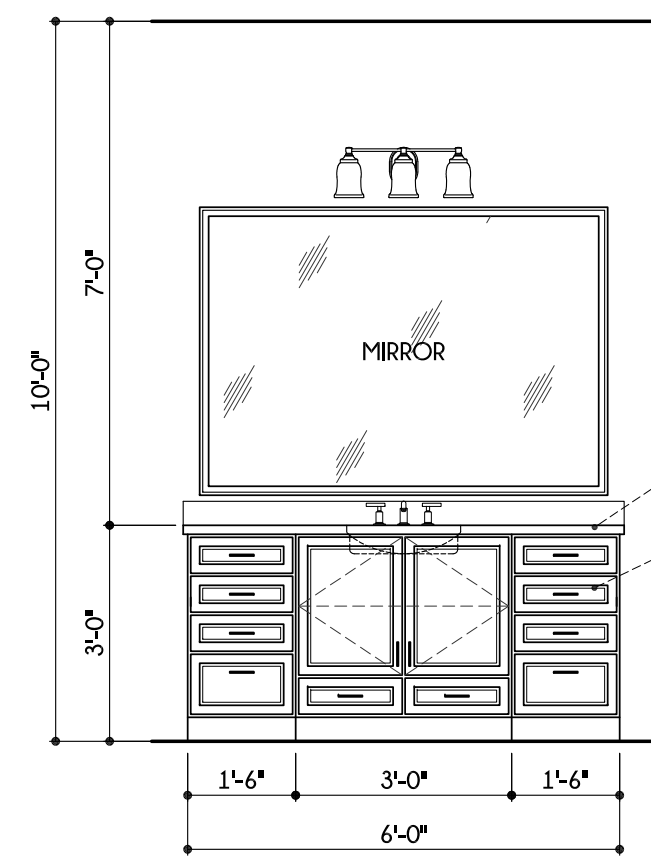


3 MASTER BATH
3/8"=1'-0"

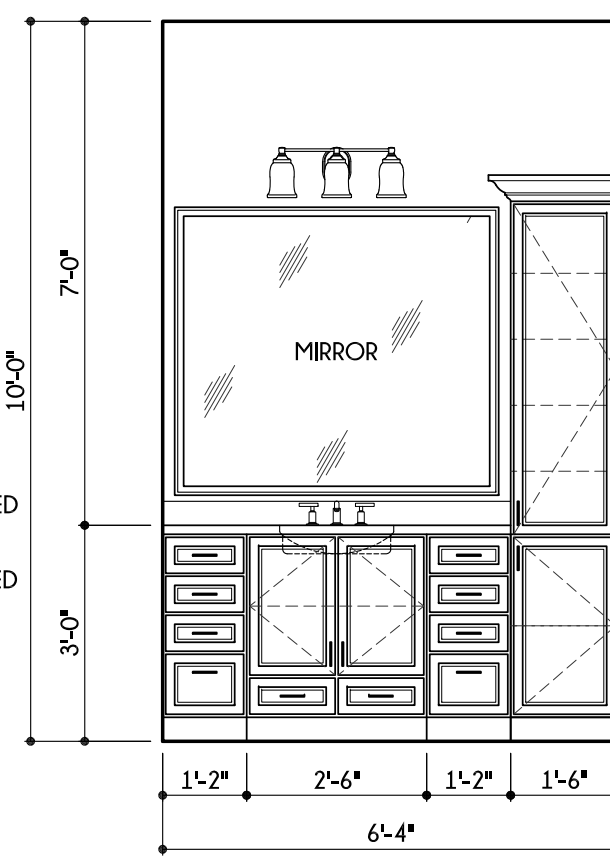


4 MASTER BATH
3/8"=1'-0"

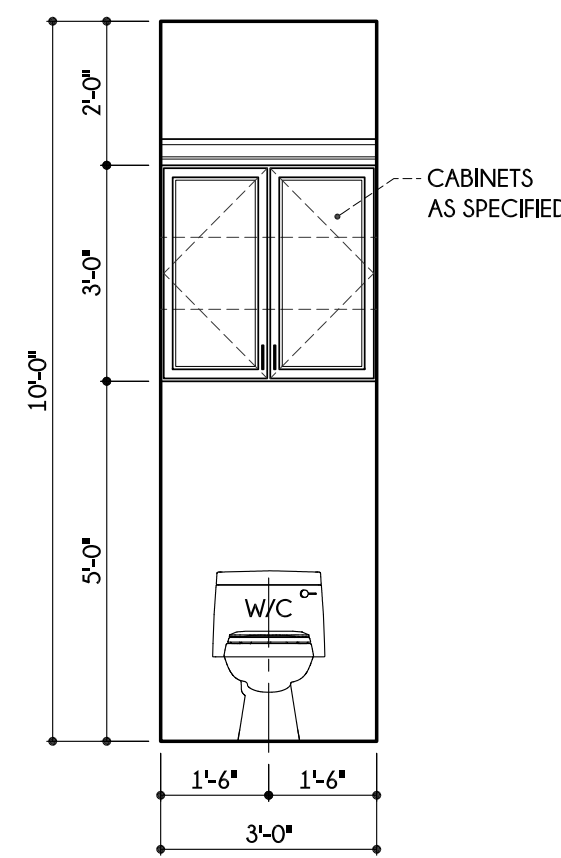


5 W/C
3/8"=1'-0"

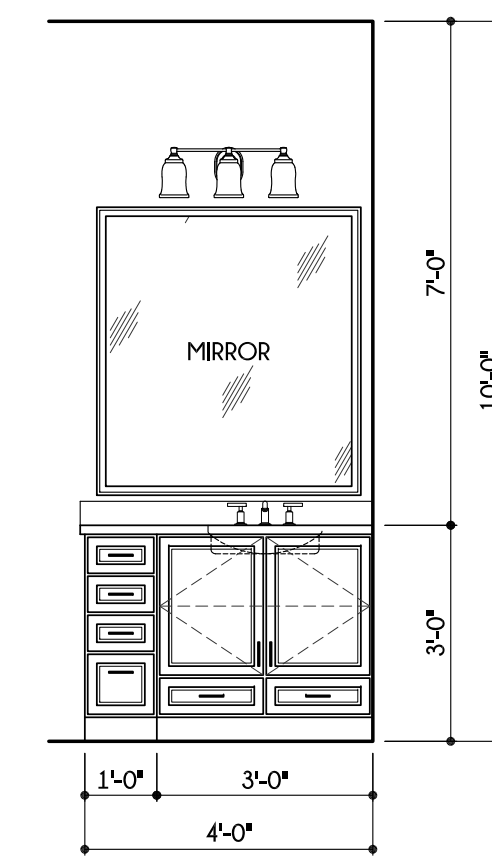


6 BATH 4
3/8"=1'-0"

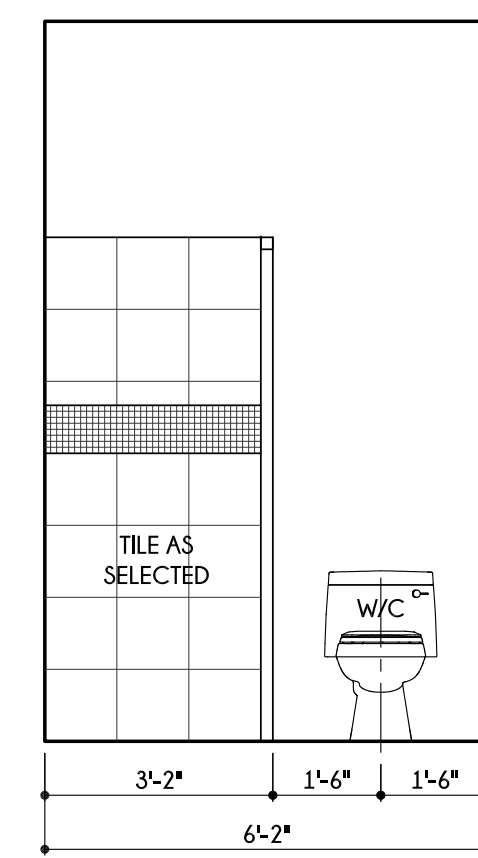


7 BATH 4
3/8"=1'-0"

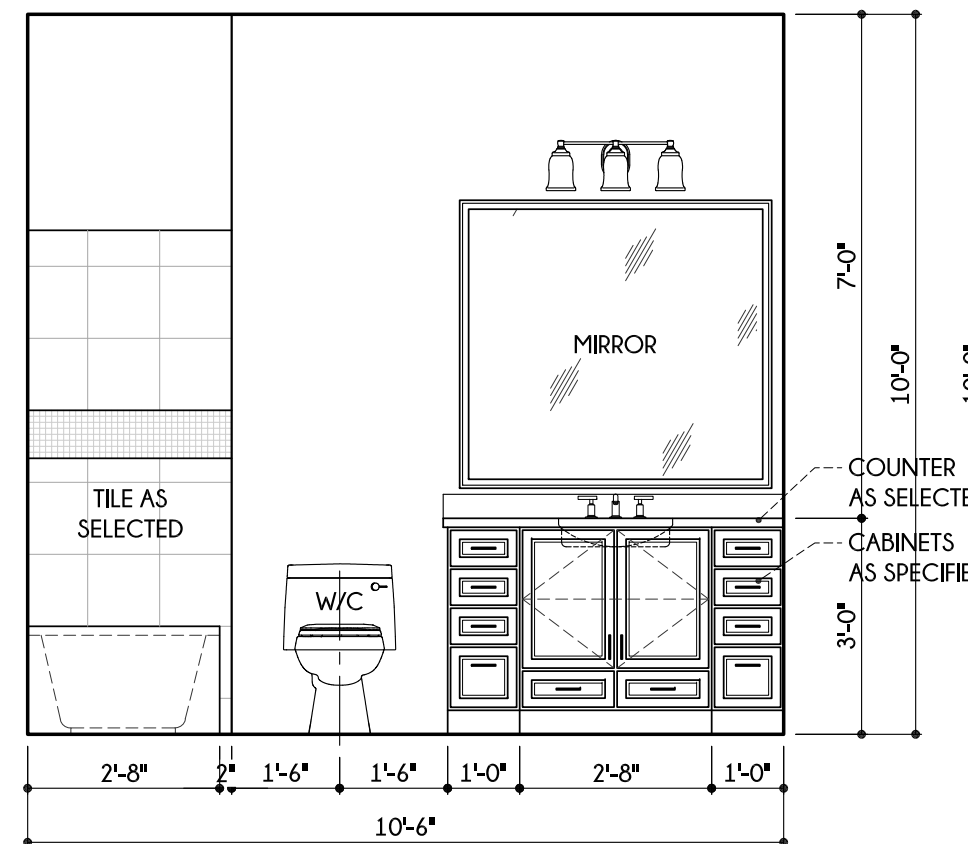


8 BATH 2
3/8"=1'-0"

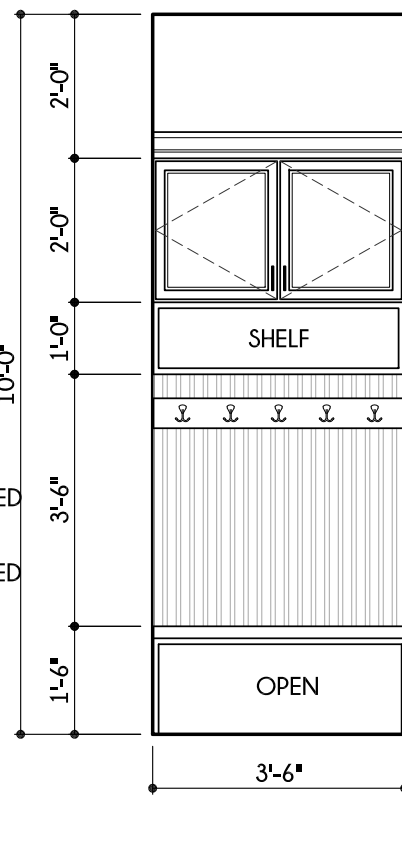


9 MUDROOM
3/8"=1'-0"

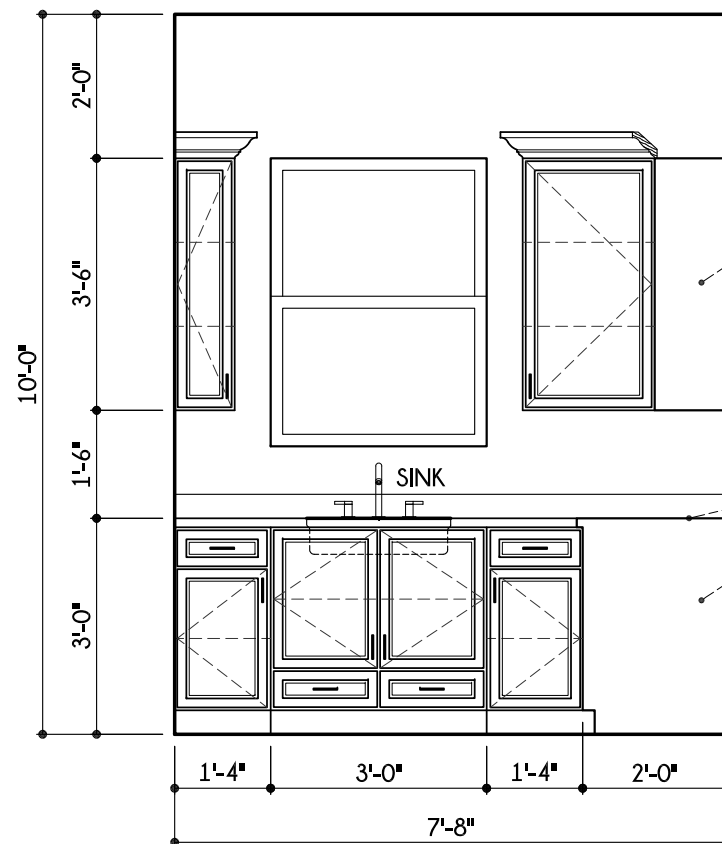


10 UTILITY
3/8"=1'-0"

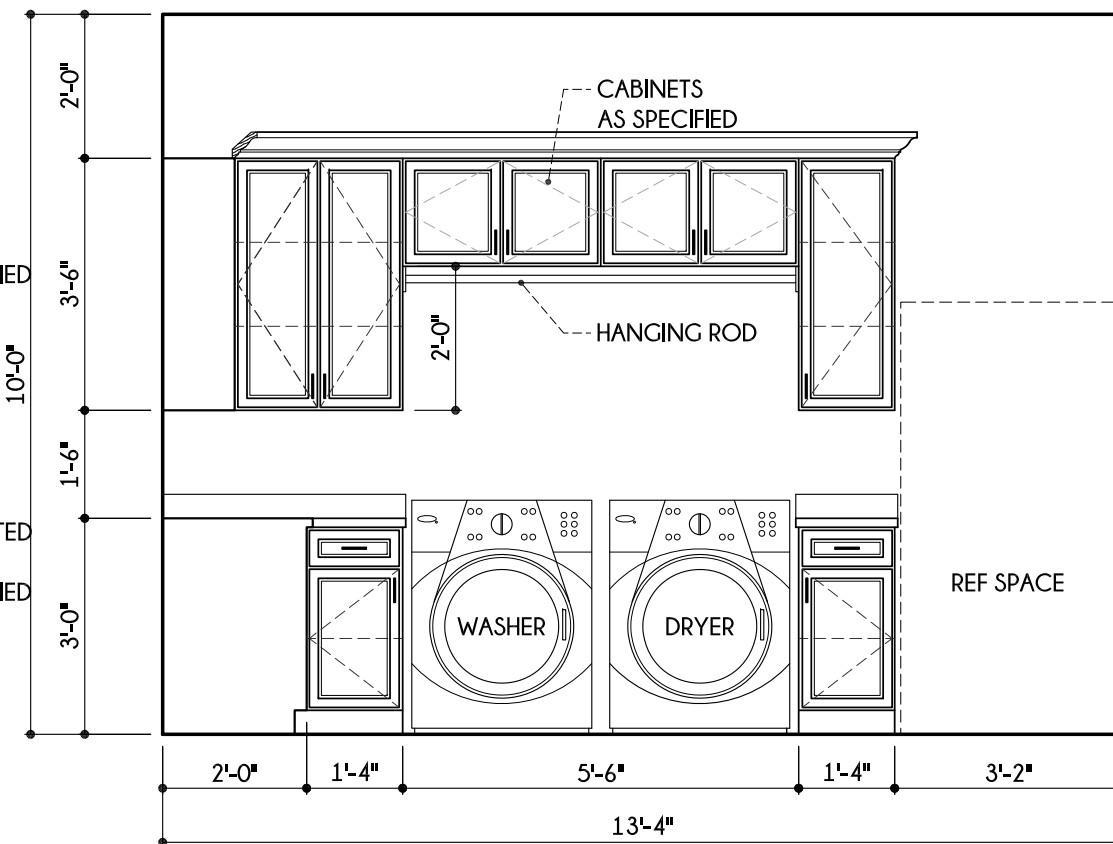


11 UTILITY
3/8"=1'-0"

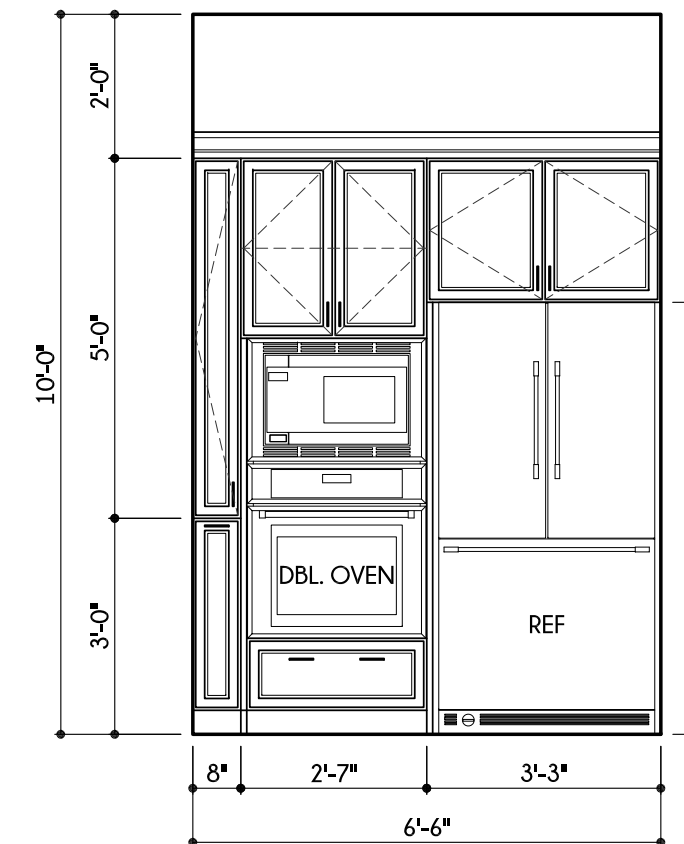


12 KITCHEN
3/8"=1'-0"

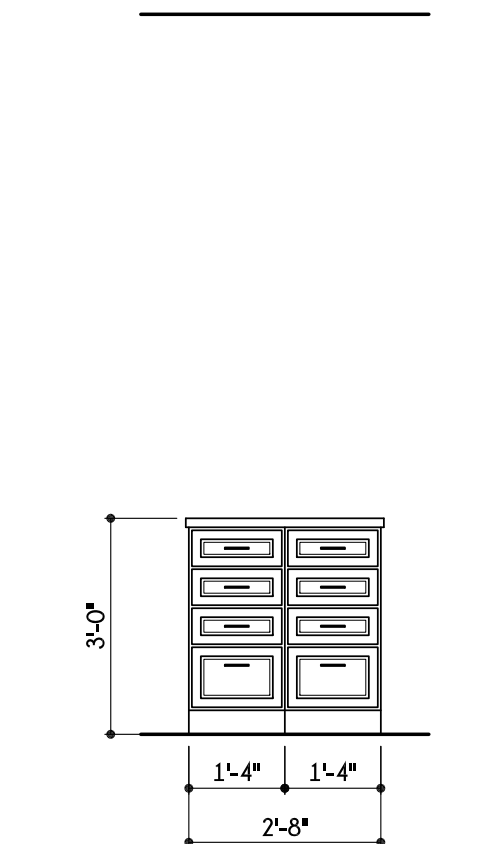


13 M. CLOSET
3/8"=1'-0"

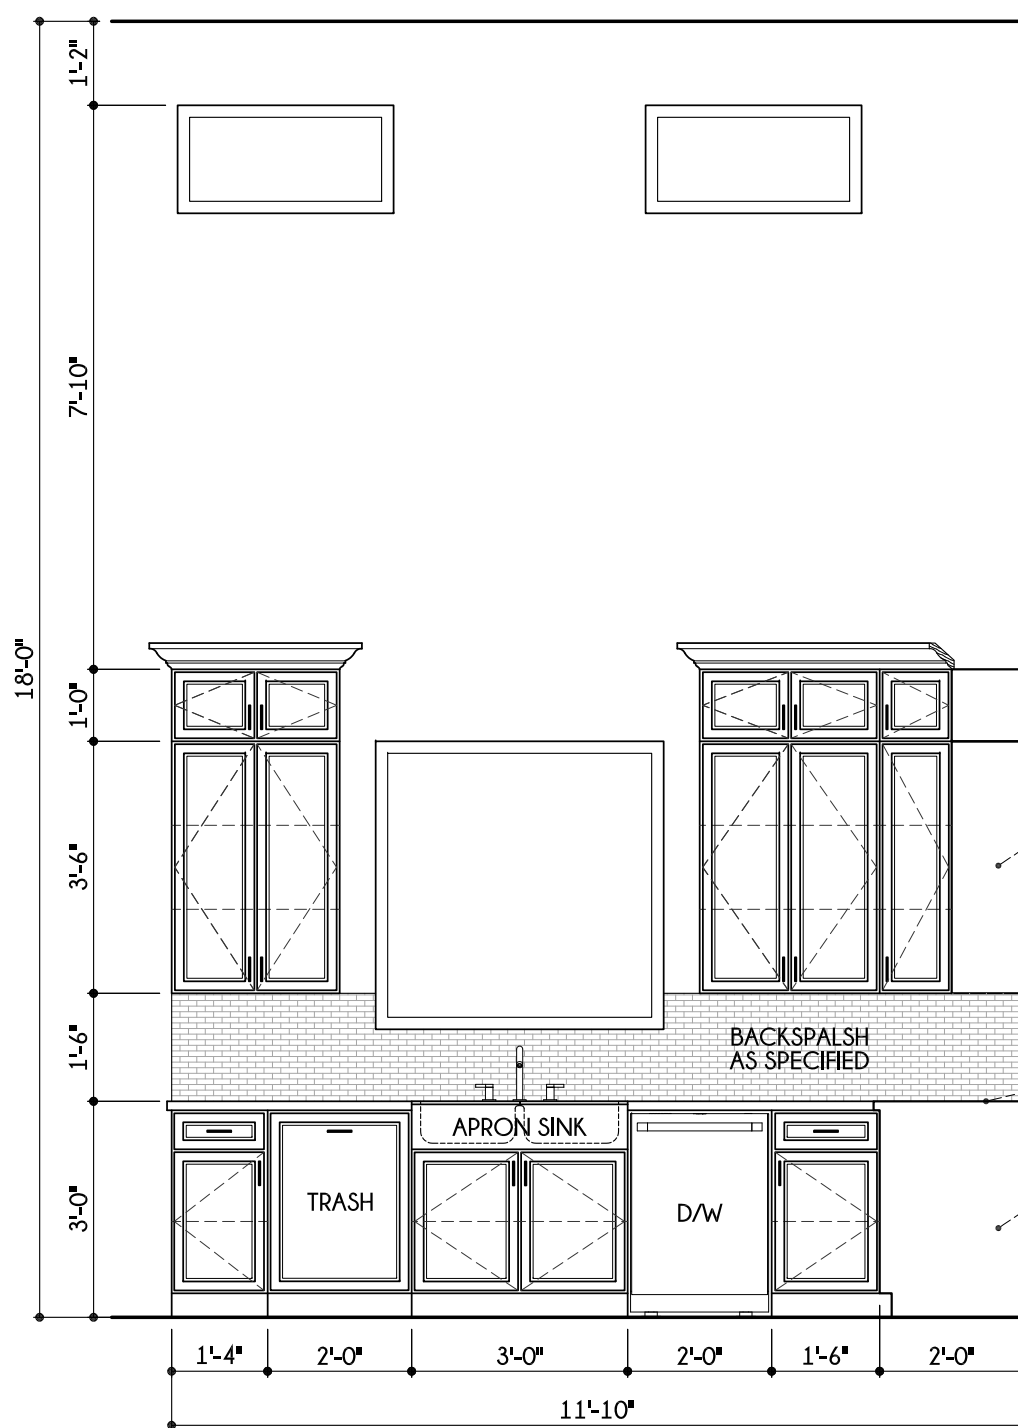


14 KITCHEN
3/8"=1'-0"

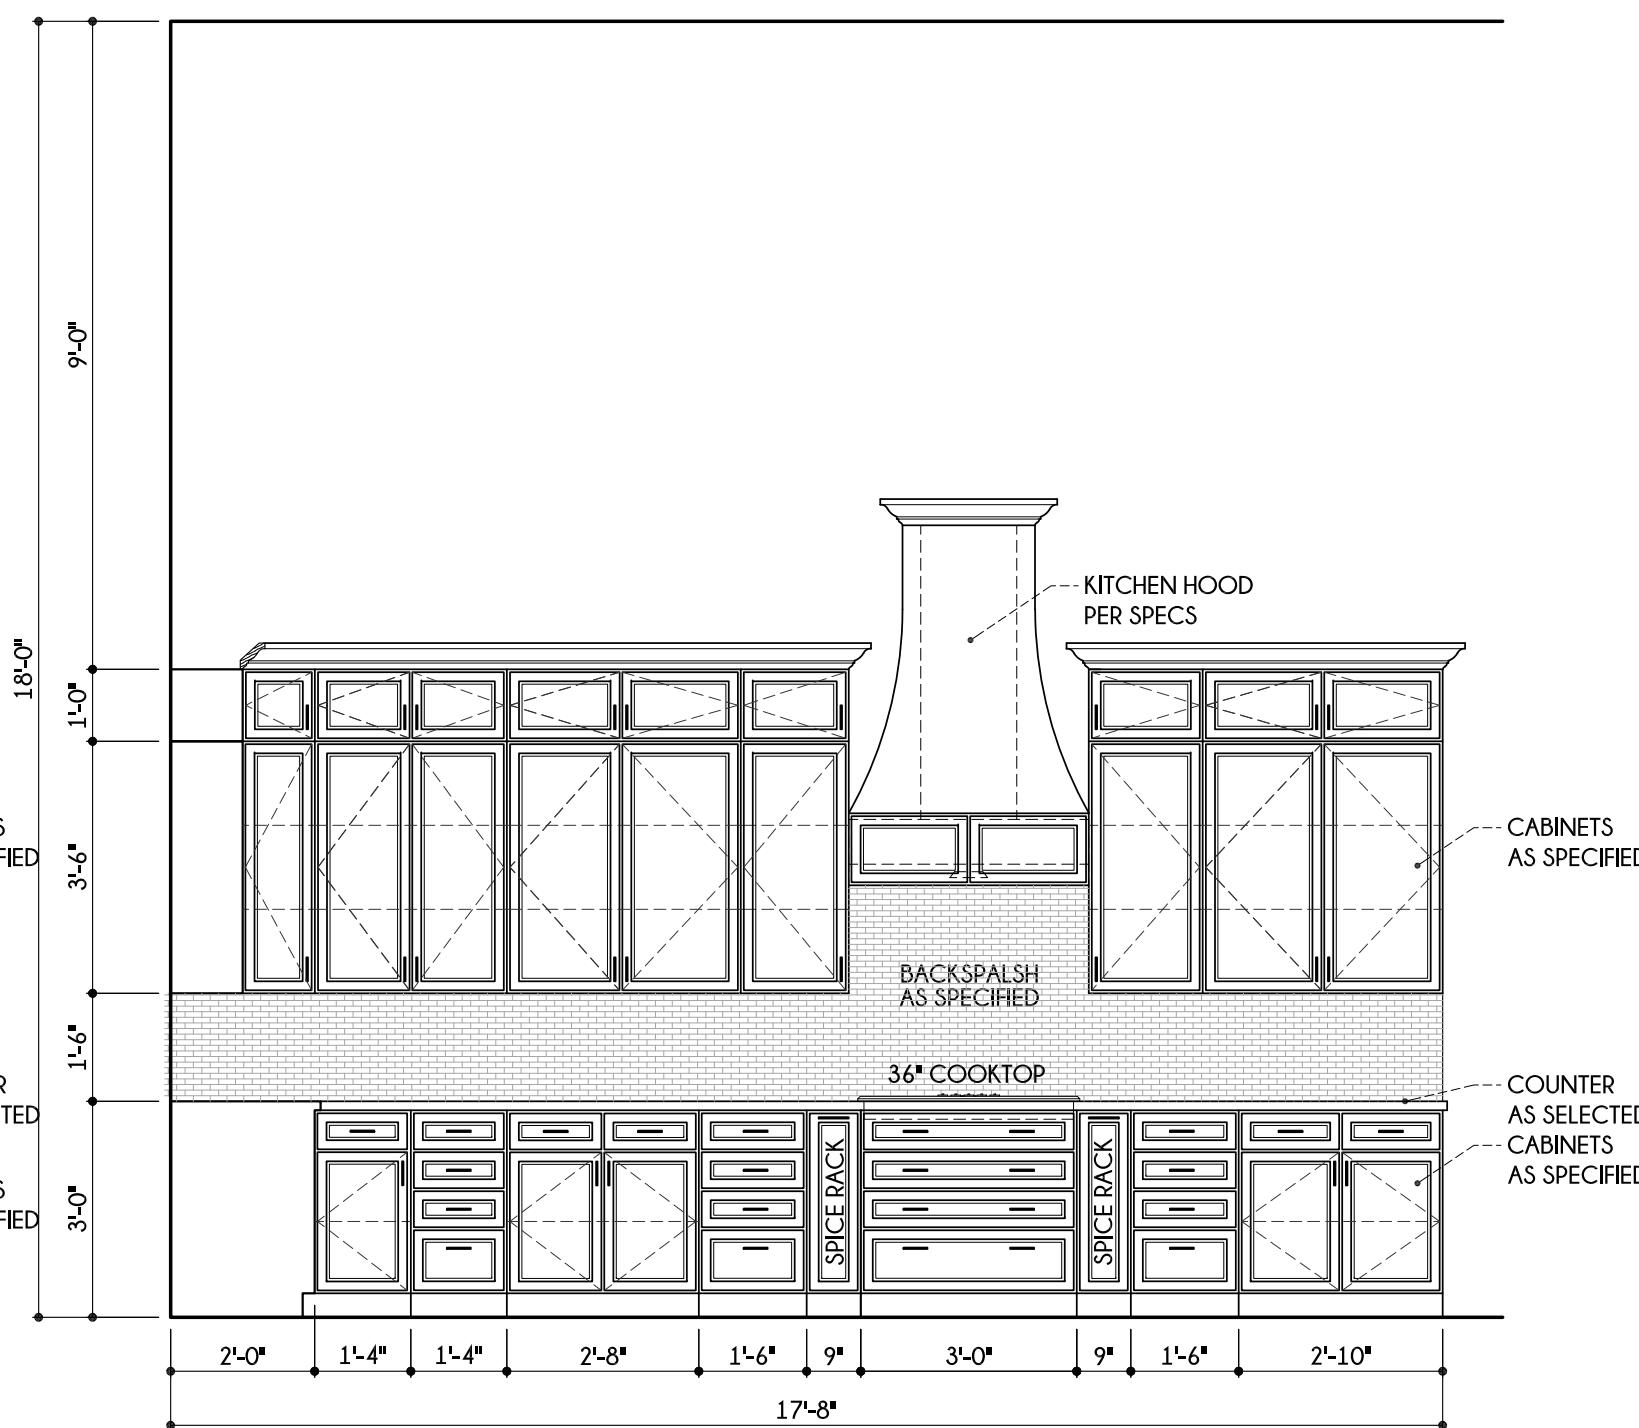


15 KITCHEN
3/8"=1'-0"

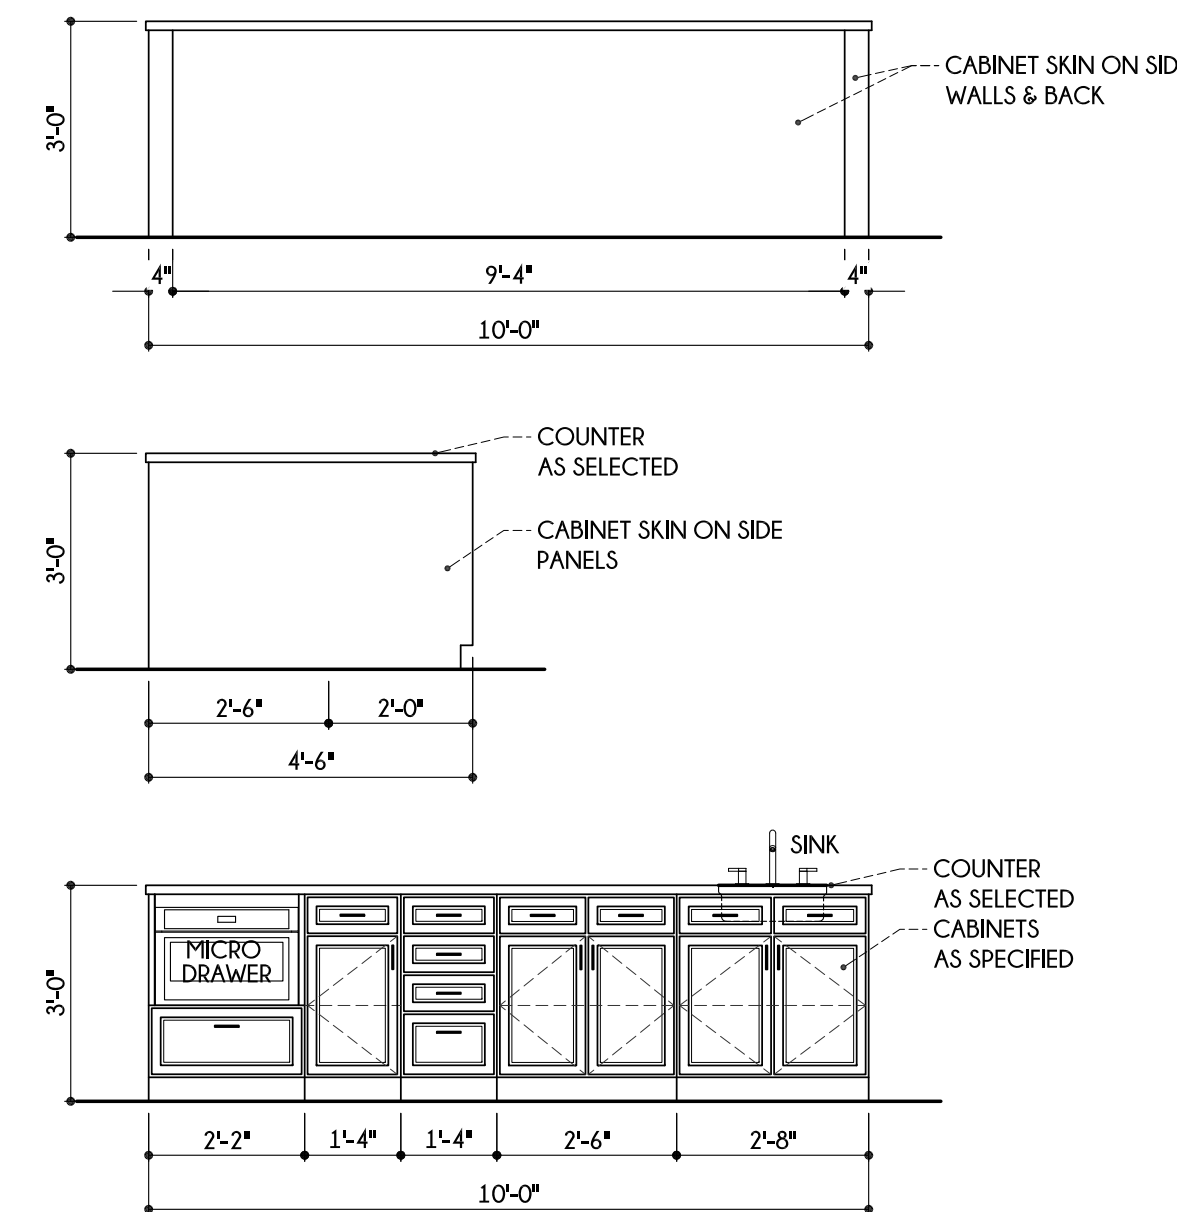


16 KITCHEN ISLAND
3/8"=1'-0"

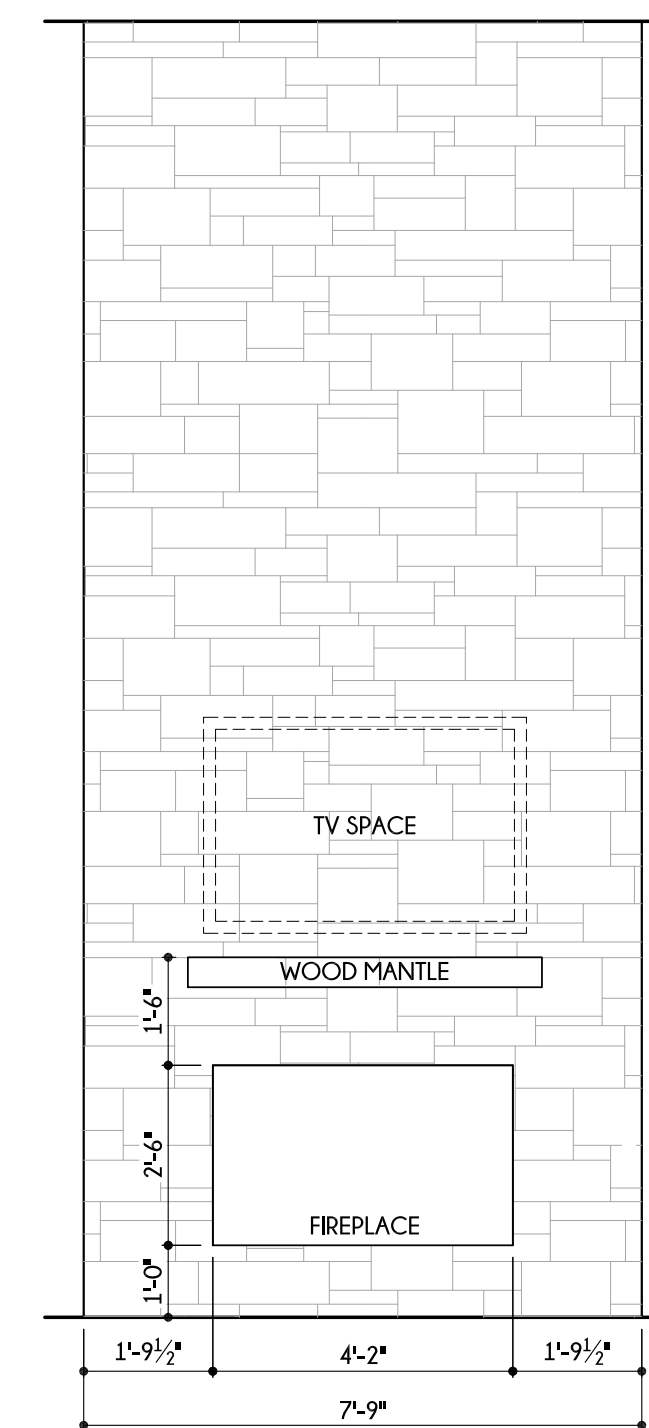

17 LIVING
3/8"=1'-0"

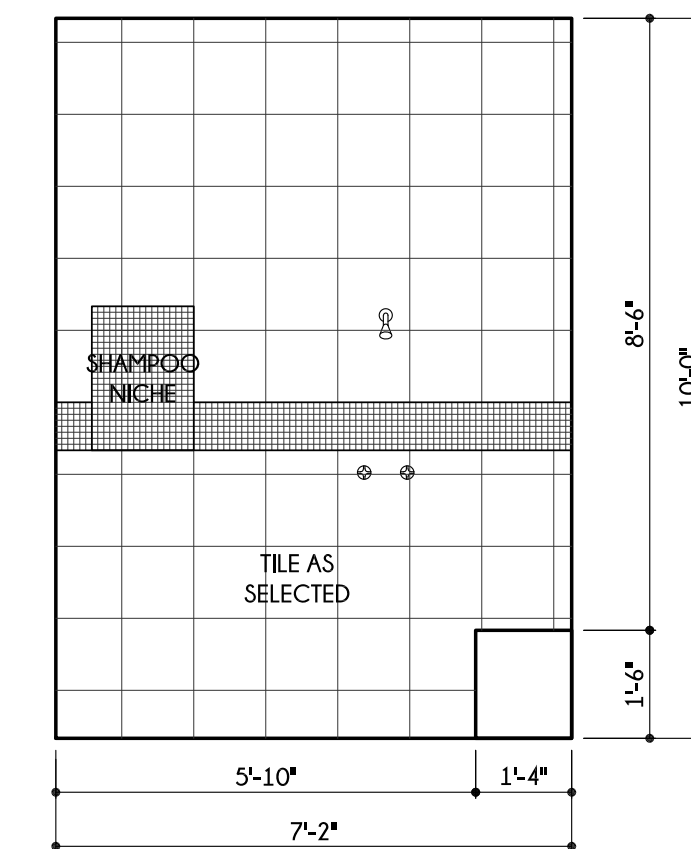

18 MASTER SHOWER
3/8"=1'-0"

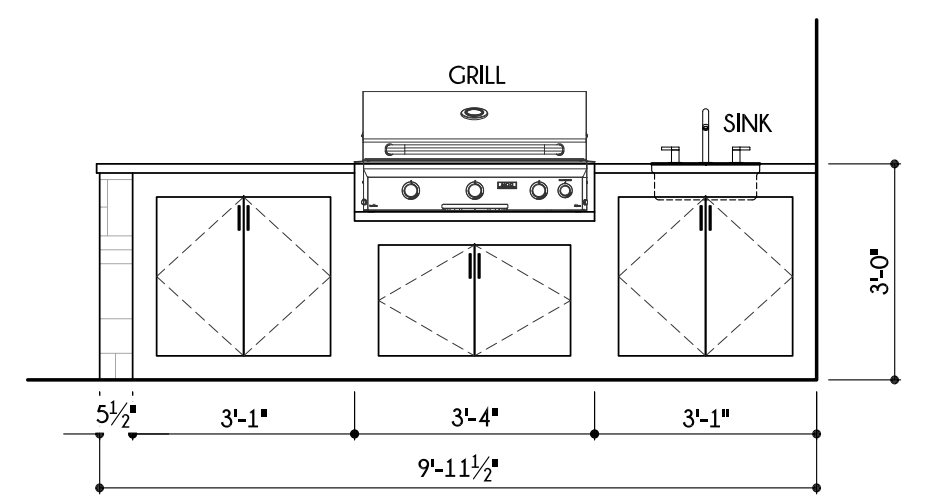

19 OUTDOOR KITCHEN
3/8"=1'-0"

This drawing is an instrument of service and shall remain the property of Silas Lacey, L.L.C. It is to be used only for the project and site described herein and is not to be reproduced, stored in a retrieval system, or transmitted in any form or by any means, electronic, mechanical, photocopying, recording, or by any information storage and retrieval system, without the prior written approval of Silas Lacey, L.L.C. Any reproduction or distribution of this drawing to other persons in connection with the project is prohibited. Any abridgment or violation of the rights of Silas Lacey, L.L.C. will be prosecuted to the fullest extent of the law.

SILAS LACEY
DESIGN & CONSTRUCTION ADMINISTRATION

SILAS LACEY
DESIGNS

PHONE: (830) 237-2166
EMAIL: info@silaslacey.com
WEBSITE: silaslacedesigns.com

INVENTORY HOME FOR
LIFESTYLE BY STADLER
11106 NINA RIDGE
THE CANYONS AT SCENIC LOOP
SAN ANTONIO, TEXAS

DATE:	1-28-22
DRAWN BY:	JZ
CHECKED BY:	JZ
REVISED BY:	

LIFESTYLE
BY STADLER

830.215.8776
StadlerCustomHomes.com